


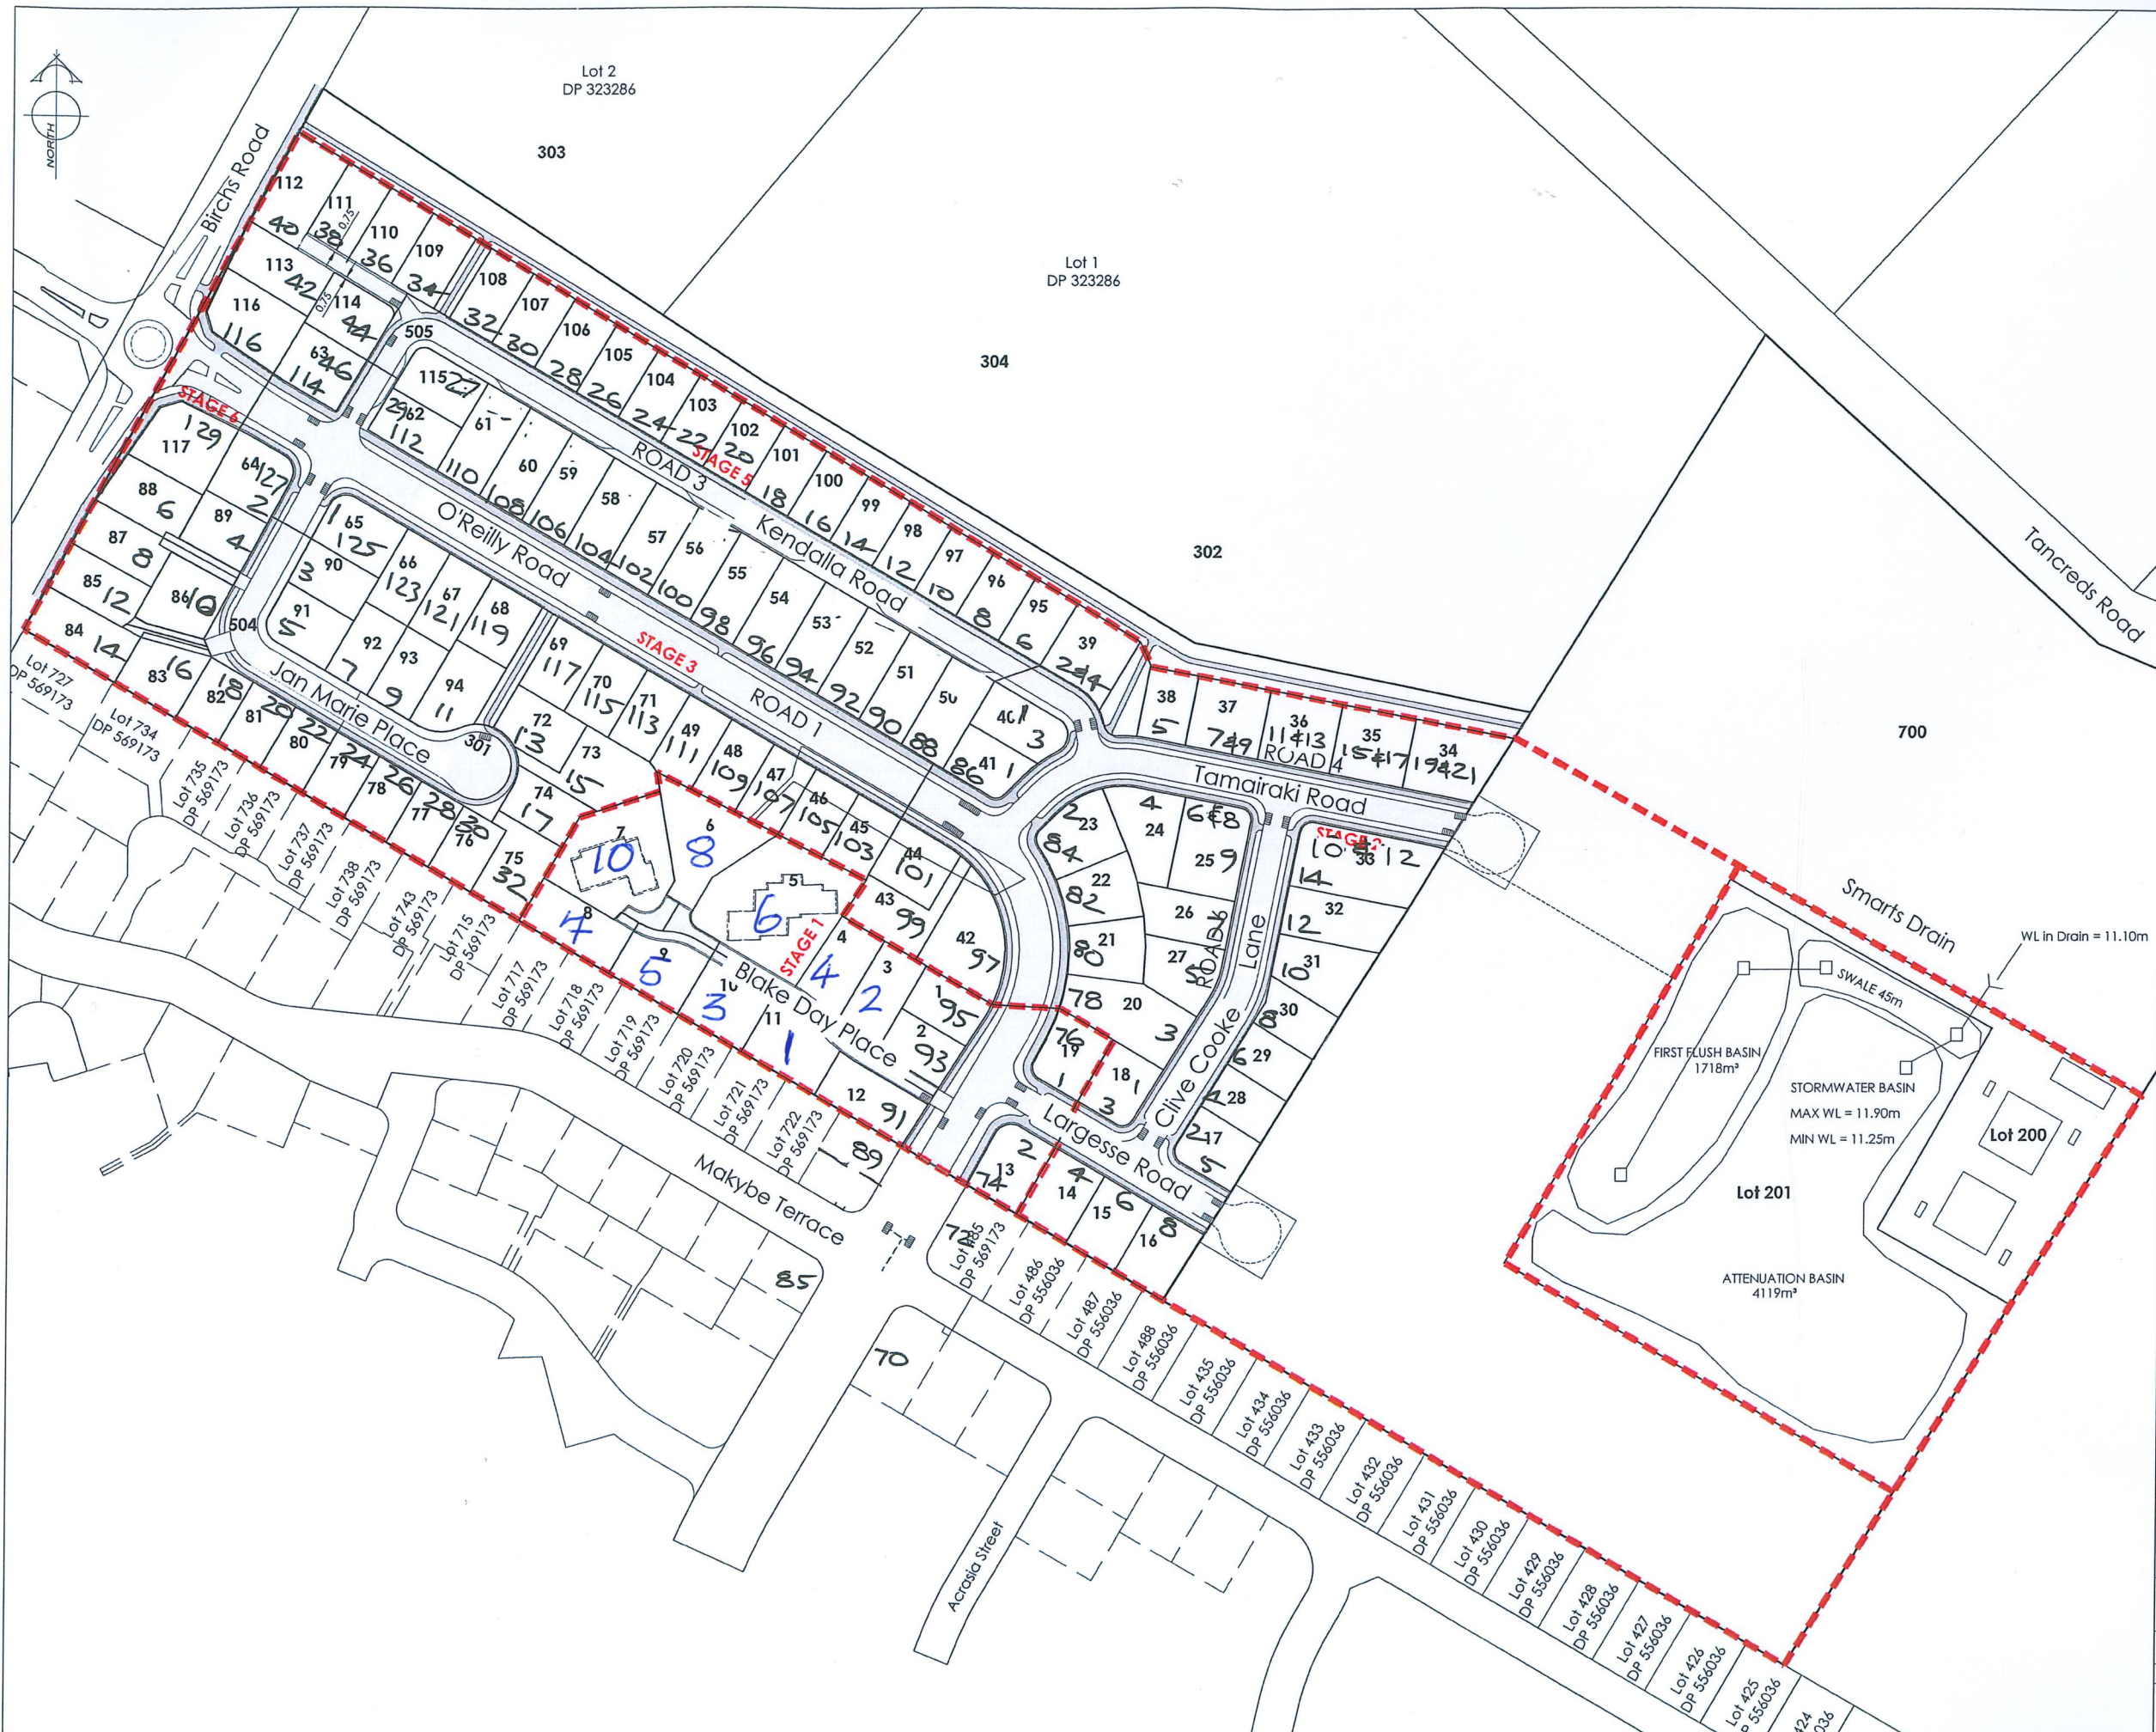

| AMENDMENTS:                                                                                                                                                                             |         |                    |
|-----------------------------------------------------------------------------------------------------------------------------------------------------------------------------------------|---------|--------------------|
| AMENDMENT                                                                                                                                                                               | DATE    | DESCRIPTION        |
| R1                                                                                                                                                                                      | 23.1.26 | Road Names Updated |
| 1) ALL WORKS IN ACCORDANCE WITH CCC IDS AND CSS PARTS 1-7 CURRENT ISSUE.                                                                                                                |         |                    |
| 2) ALL PLANS ARE TO BE READ AND DISTRIBUTED AS A COMPLETE SET. ANY DISCREPANCIES ARE TO BE BROUGHT TO THE ATTENTION OF THE ENGINEER FOR CLARIFICATION.                                  |         |                    |
| 3) ELECTRICITY & TELECOM SERVICES NOT SHOWN, REFER TO ELECTRICAL & COMMUNICATION PLANS FOR DUCT LOCATIONS.                                                                              |         |                    |
| 4) TRENCHING AND INSTALLATION OF POWER AND TELECOM SERVICES TO BE PROVIDED IN ACCORDANCE WITH SERVICE PROVIDERS PLANS AND SPECIFICATIONS.                                               |         |                    |
| 5) EXISTING SERVICES HAVE BEEN DIGITISED FROM SERVICE AUTHORITY PLANS; COMPLETENESS AND ACCURACY ARE NOT GUARANTEED. ALL SERVICES TO BE FULLY SEARCHED AND PILOTTED PRIOR TO TRENCHING. |         |                    |
| 6) CONTOUR INTERVAL: 0.2m MINOR, 1.0m MAJOR.                                                                                                                                            |         |                    |
| 7) ORIGIN OF LEVELS                                                                                                                                                                     |         |                    |
| 8) CONTROL OF STORMWATER, SEDIMENT AND DUST ON SITE IS THE RESPONSIBILITY OF THE CONTRACTOR                                                                                             |         |                    |
| 9) ALL ROW AND DRIVEWAYS ARE TO HAVE 50mm DUCTS INSTALLED FOR COMMUNICATIONS AND POWER SUPPLY.                                                                                          |         |                    |

|                                                                                       |                      |                                                                                       |              |
|---------------------------------------------------------------------------------------|----------------------|---------------------------------------------------------------------------------------|--------------|
| LEGEND :                                                                              |                      |                                                                                       |              |
|  | NEW ASPHALT PAVEMENT |  | NEW FOOTPATH |
| KERB _____                                                                            |                      | KERB _____                                                                            |              |
| DESIGNED BY                                                                           | NAME                 | SIGNED                                                                                | DATE         |
| CHECKED BY                                                                            |                      |                                                                                       |              |

**DAVE LOVELL-SMITH**  
PLANNING SURVEYING ENGINEERING

116 Wrights Road P O Box 679 Christchurch 8140, New Zealand  
Telephone: 03 379-0793 Website: www.dls.co.nz E-mail: office@dls.co.nz

JOB TITLE:

**555 Birchs Road &  
447 Tancred's Road, Lincoln**

SHEET TITLE:

**Road Names**

DRAWING STATUS

**For Information**

SCALE: 1:1000@A1  
1:2000@A3

DATE: January 2026

CAD FILE: J:\21270\Road names\E21270 Road Names R1.dwg

DRAWING No: **E.21270**

SHEET No: 1 OF 1

REVISION: **R1**