
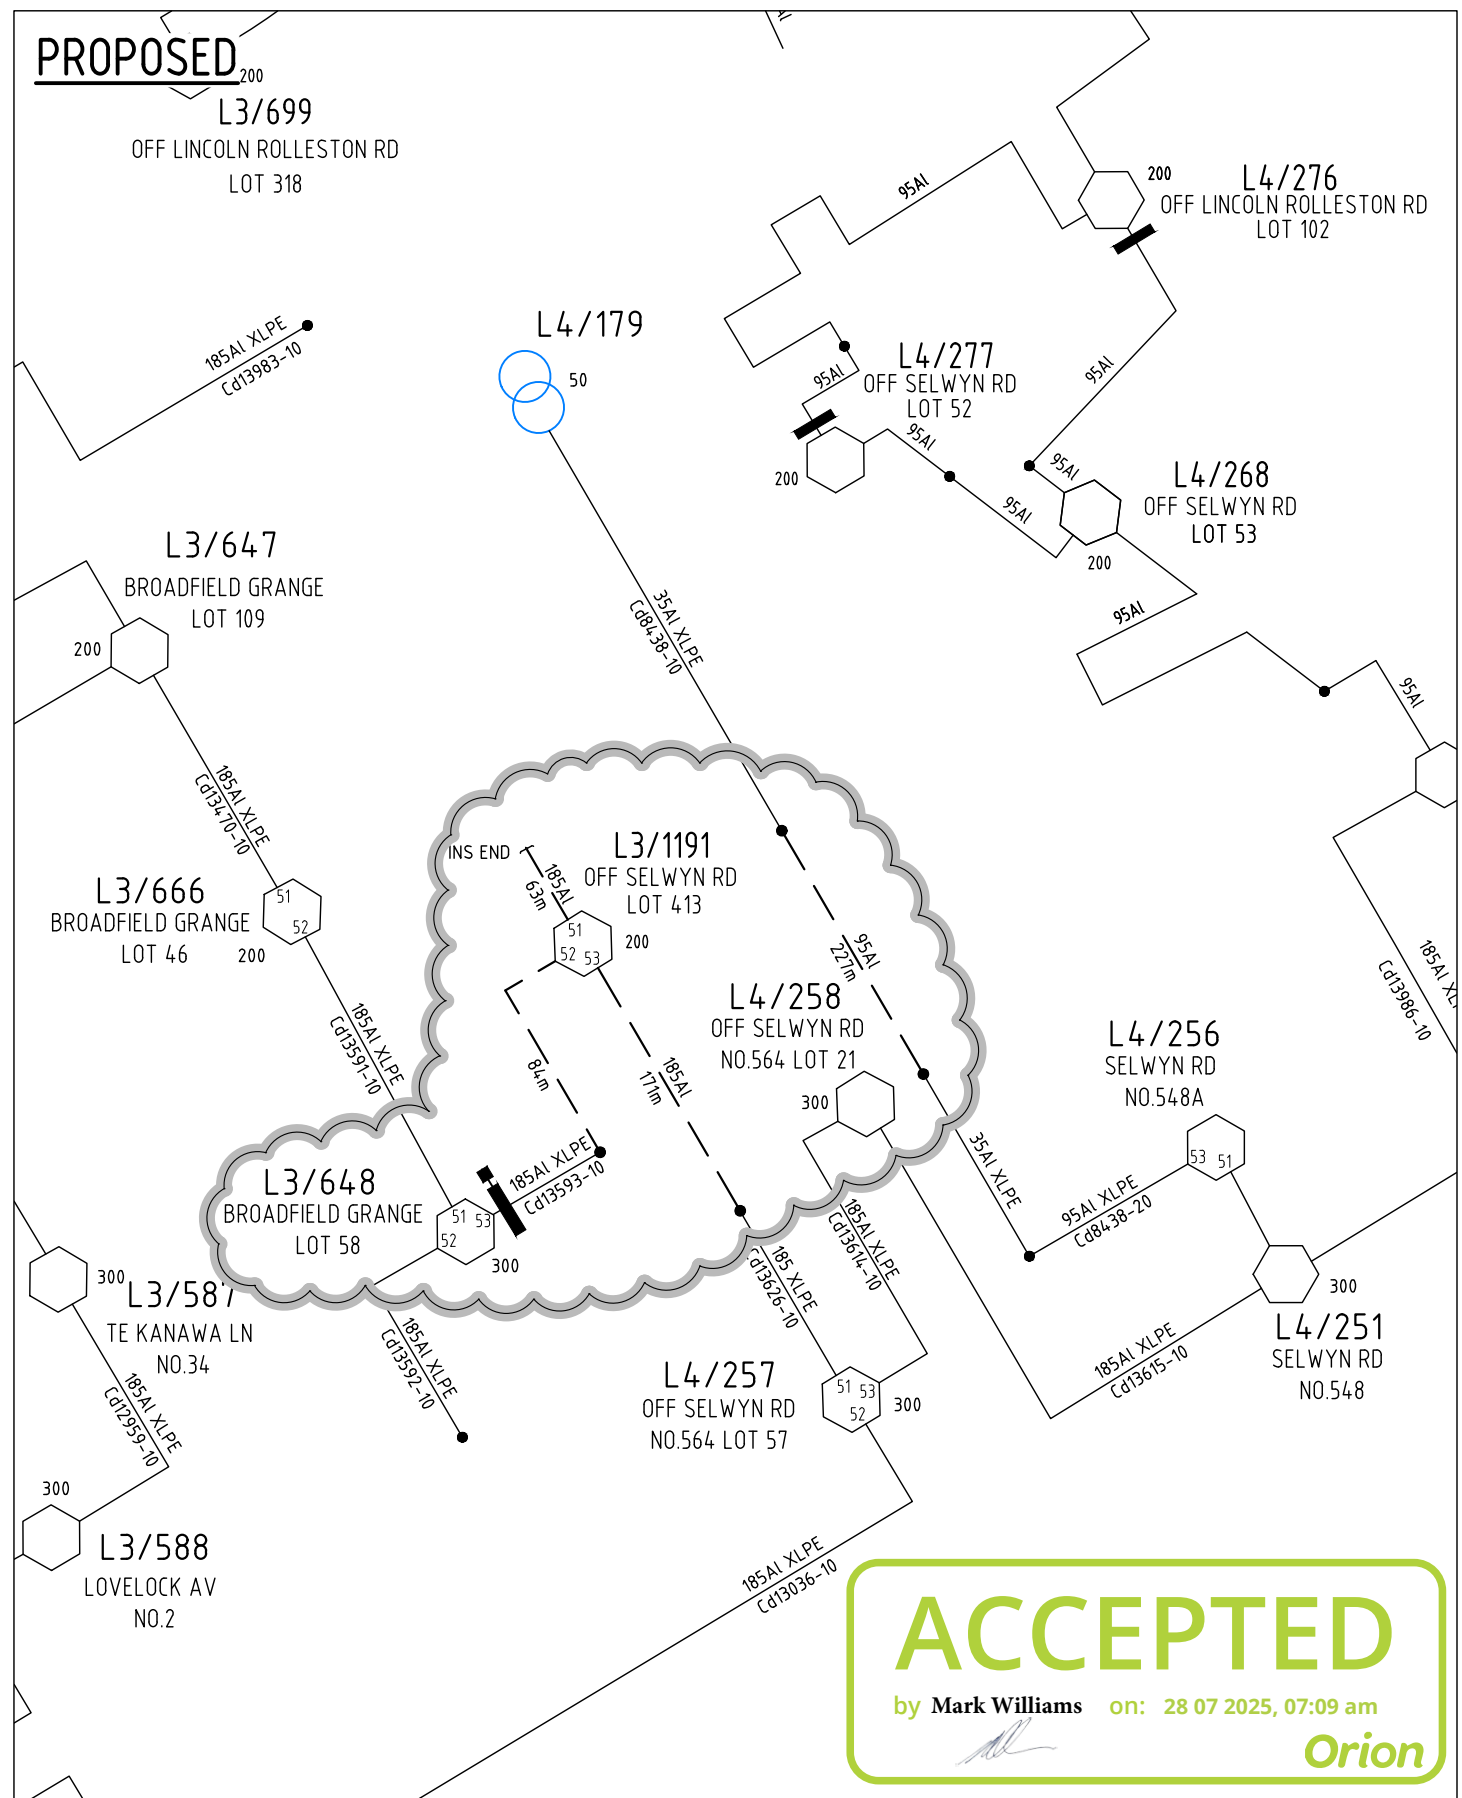


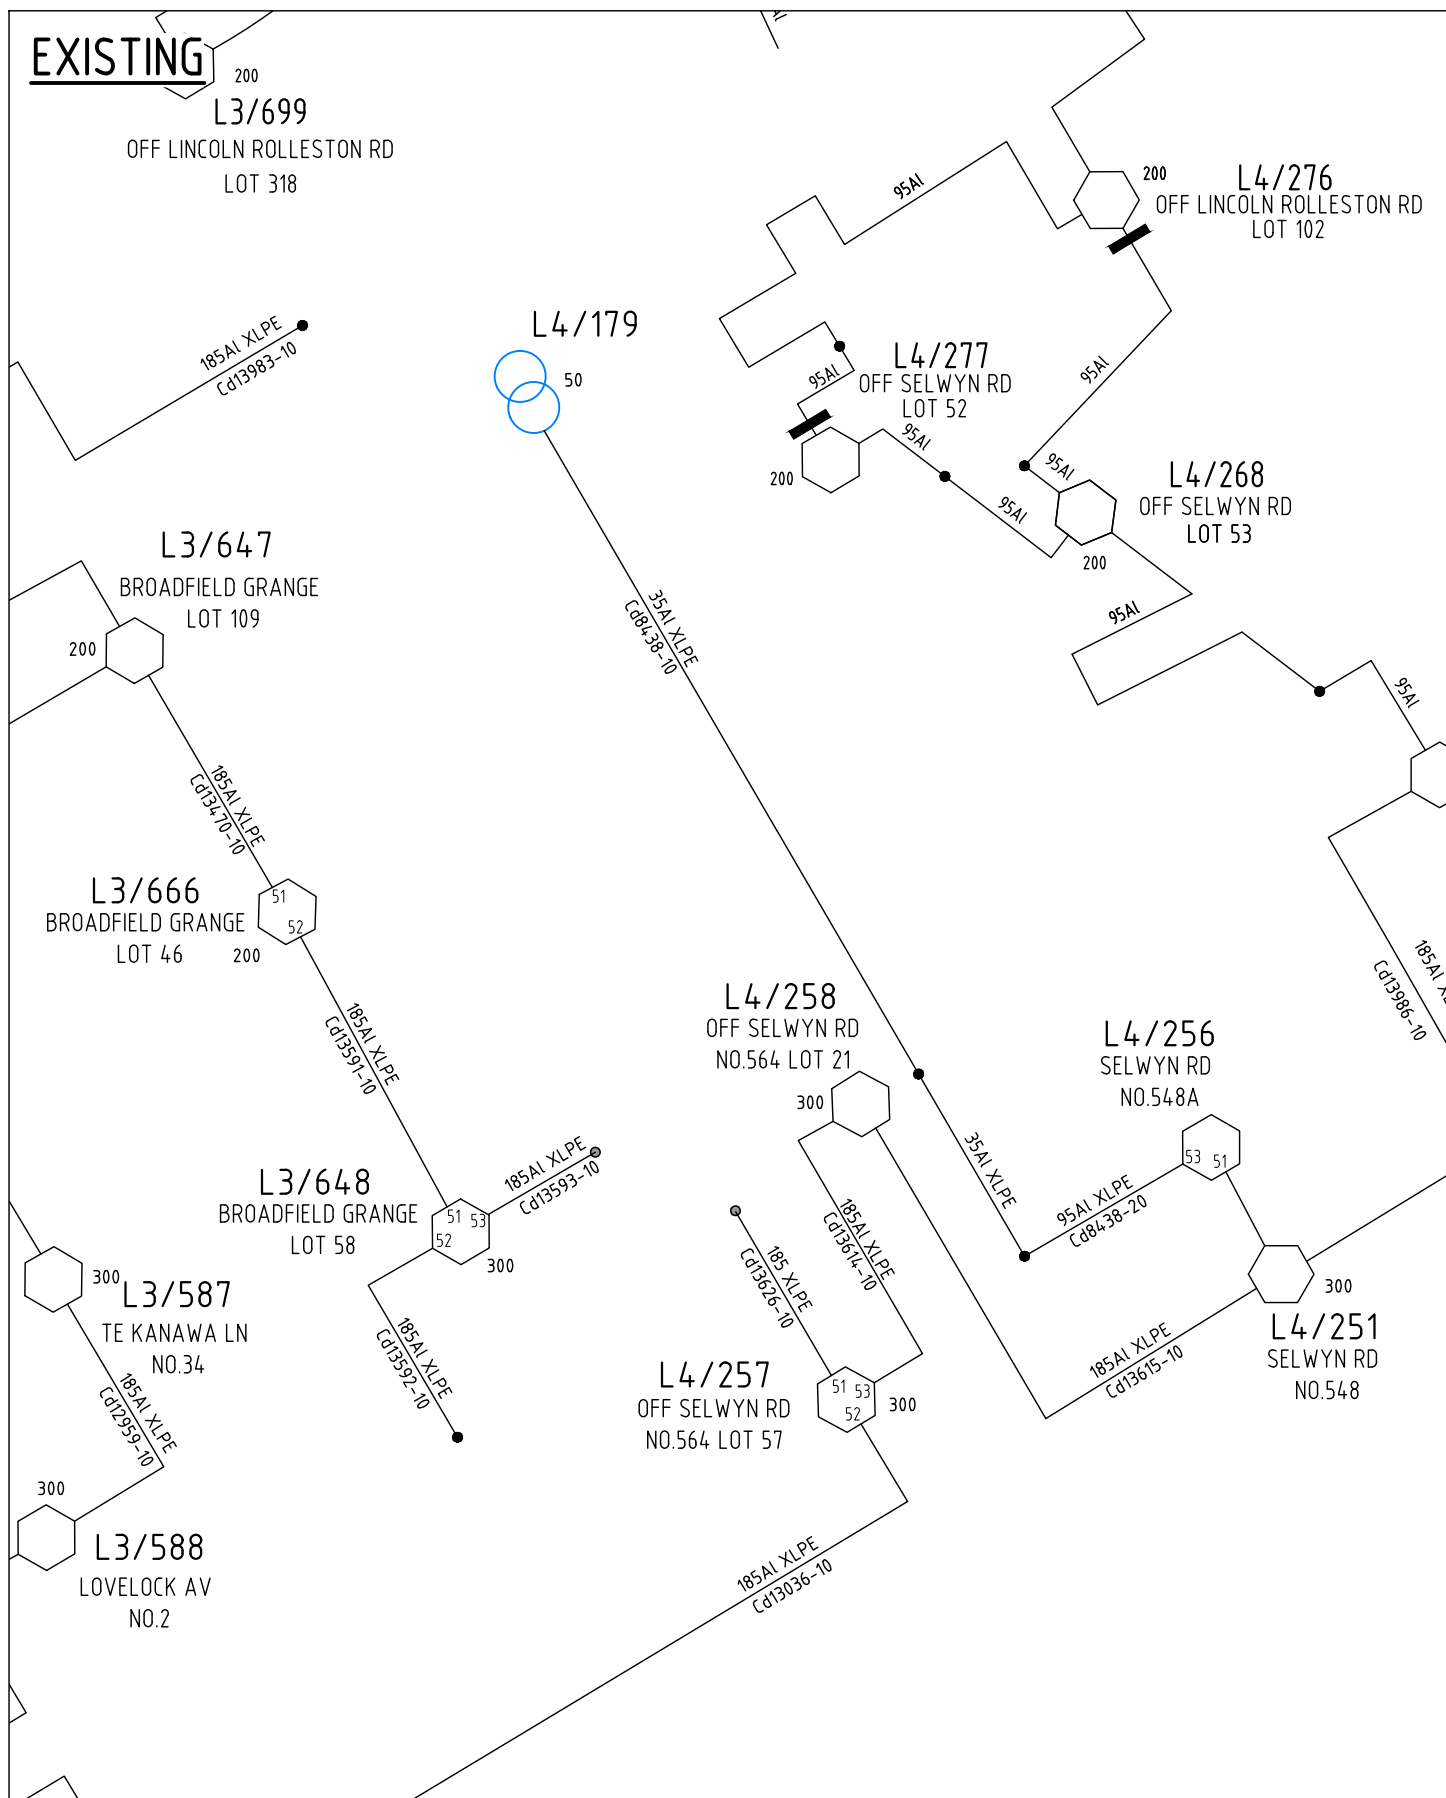

ACCEPTED
by Mark Williams on: 28 07 2025, 07:09 am
Orion


ISSUE	DESCRIPTION	DATE	DESIGN	DRAWN	CHECKD	TASK	NAME	SIGNATURE	DATED
A	ORIGINAL ISSUE	02/07/25	A.M.	A.M.	N.J.	DESIGNED	A. MECHEN		30/05/25
						DRAWN	A. MECHEN		30/05/25
						CHECKED	N. JARRETT		02/07/25
						APPROVED			
						ORN101904.9			A

CONNETICS LIMITED. ALL RIGHTS RESERVED
UNAUTHORISED USE PROHIBITED

BROADFIELD GRANGE STAGE 10

24 LOT RESIDENTIAL SUBDIVISION
HV SCHEMATICS

connetics ALLWAYS CONNECTING		
SCALE(SIZE)	DRAWING NO.	SHEET
NTS (A3)	106908	S10-HV-1

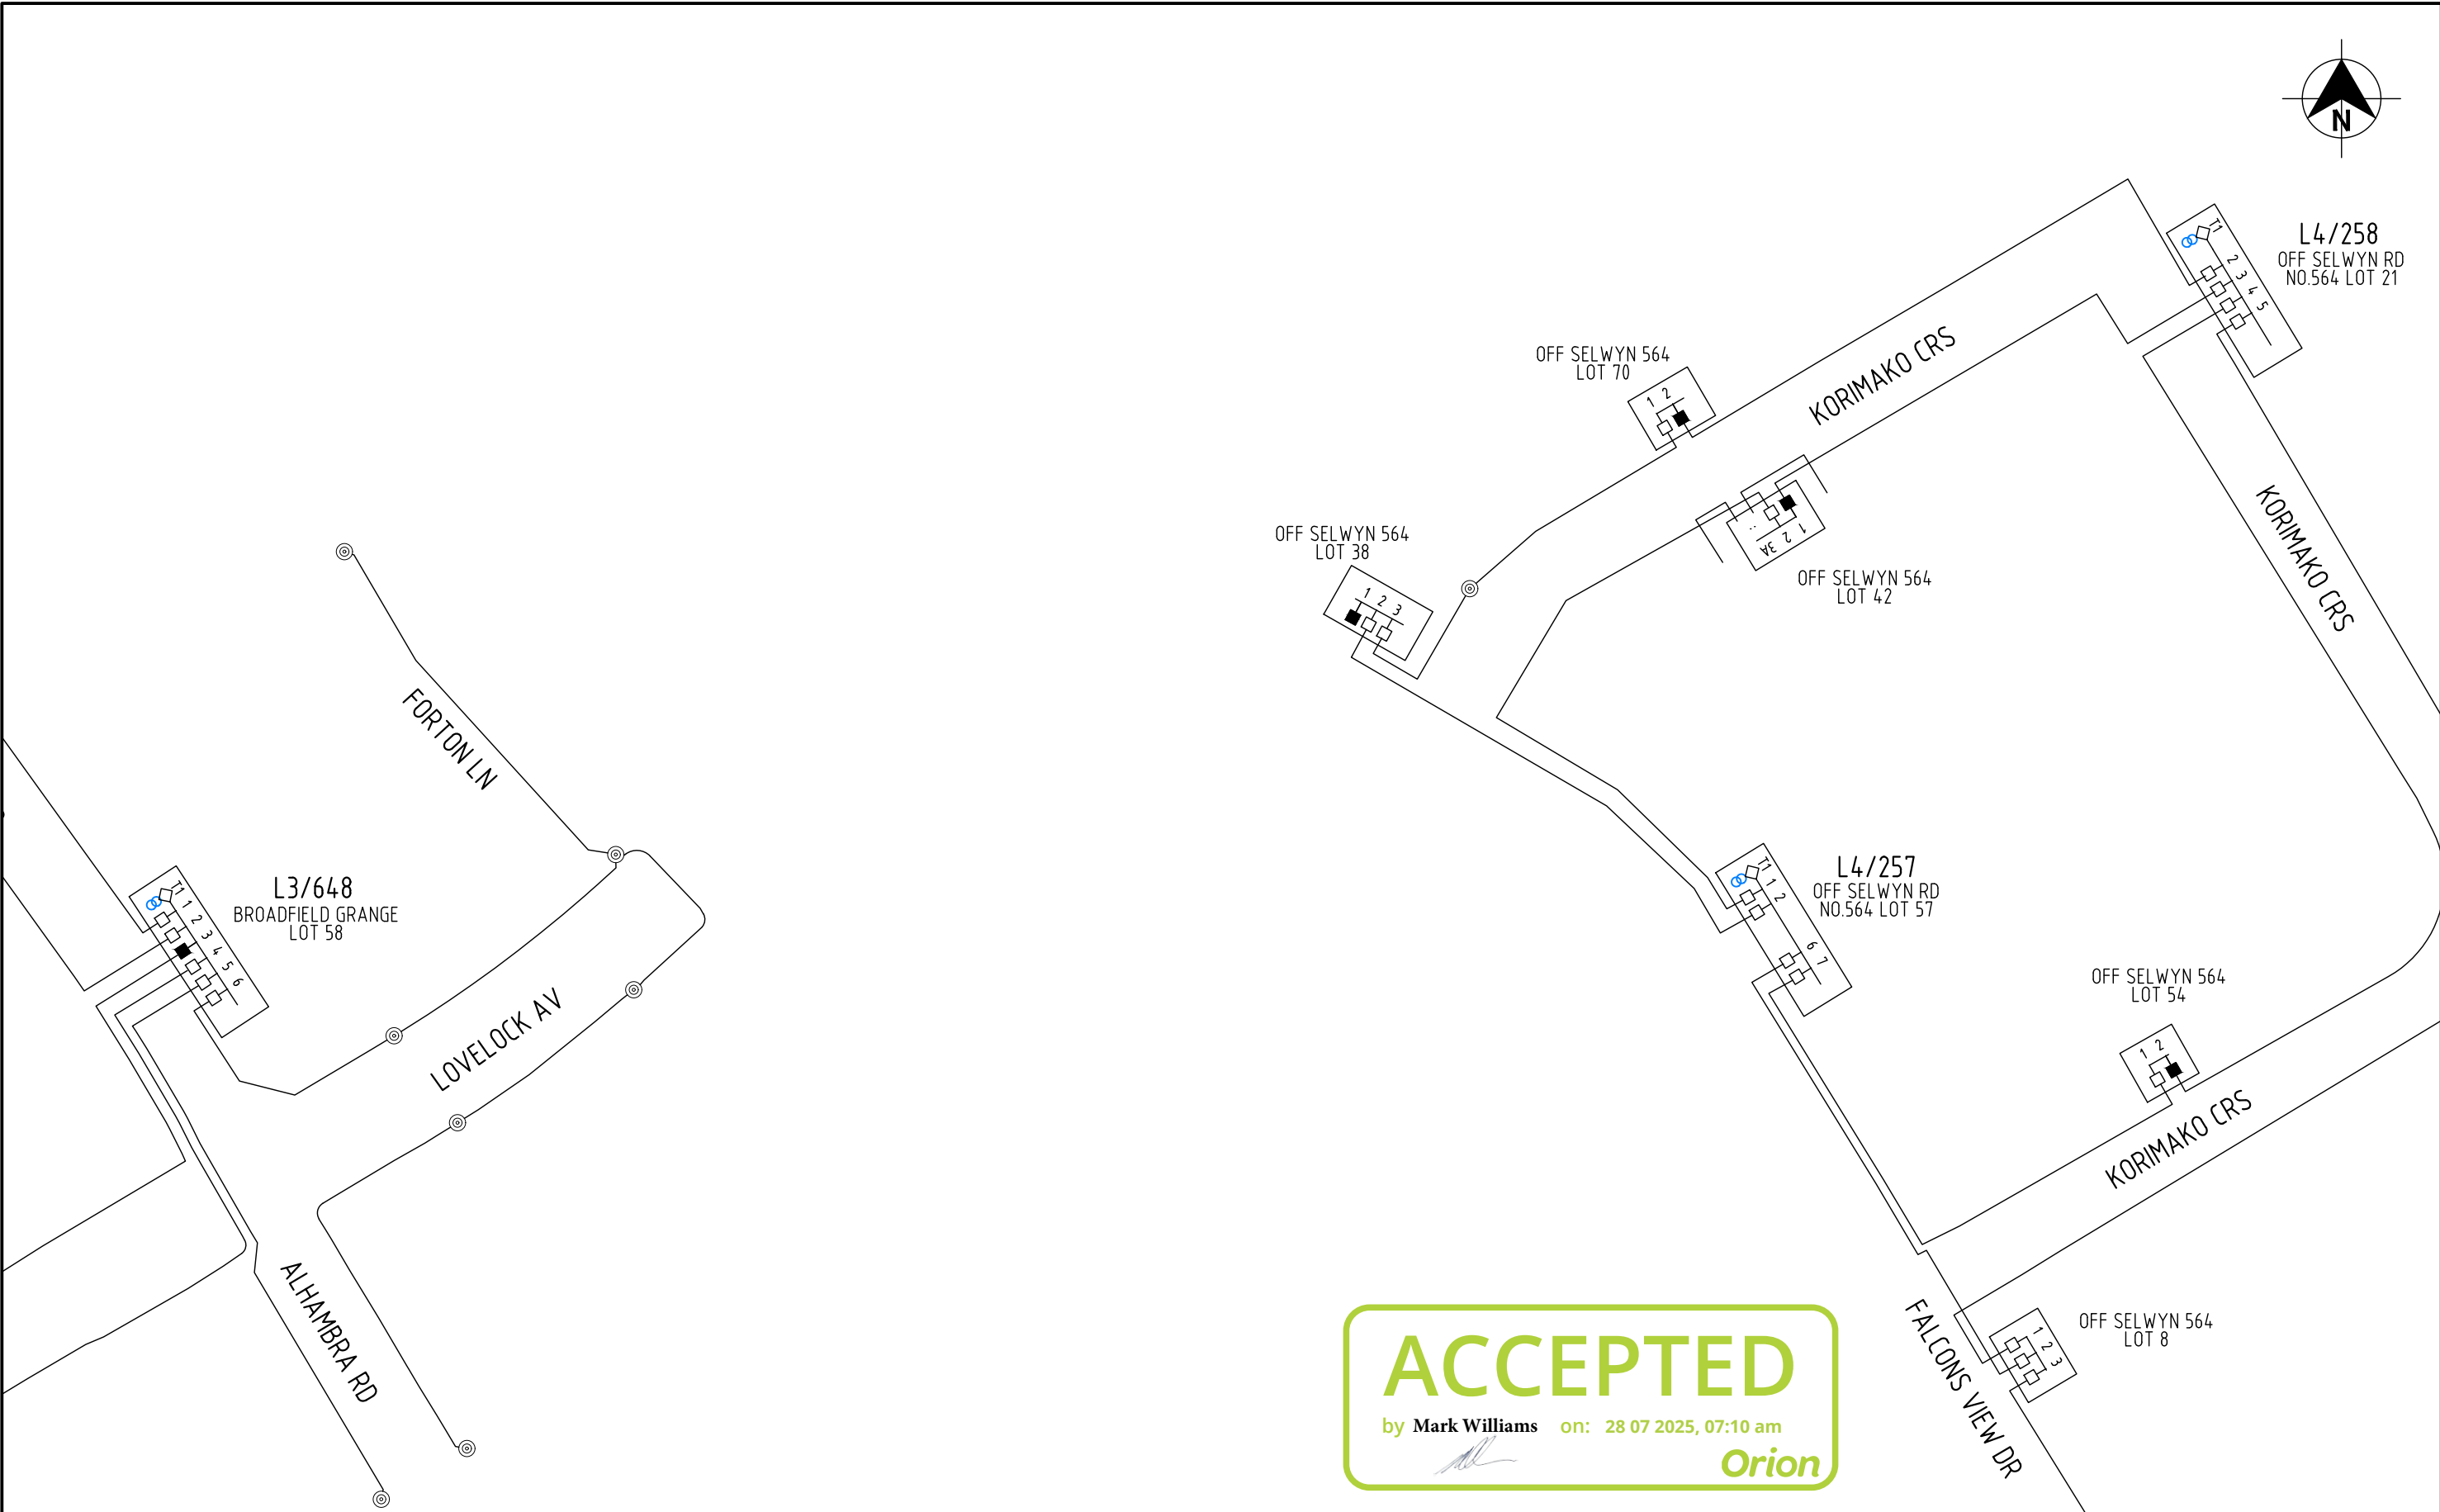

ISSUE	DESCRIPTION	DATE	DESIGN	DRAWN	CHECKD	TASK	NAME	SIGNATURE	DATED
A	ORIGINAL ISSUE	02/07/25	A.M.	A.M.	N.J.	DESIGNED	A. MECHEN		30/05/25
						DRAWN	A. MECHEN		30/05/25
						CHECKED	N. JARRETT		02/07/25
						APPROVED			
						ORN101904.9	CONNETICS LIMITED. ALL RIGHTS RESERVED UNAUTHORISED USE PROHIBITED		A


BROADFIELD GRANGE STAGE 10

24 LOT RESIDENTIAL SUBDIVISION
LV SCHEMATICS - EXISTING



ALLWAYS CONNECTING

SCALE(SIZE)	DRAWING NO.	SHEET
NTS (A3)	106908	S10-LV-1

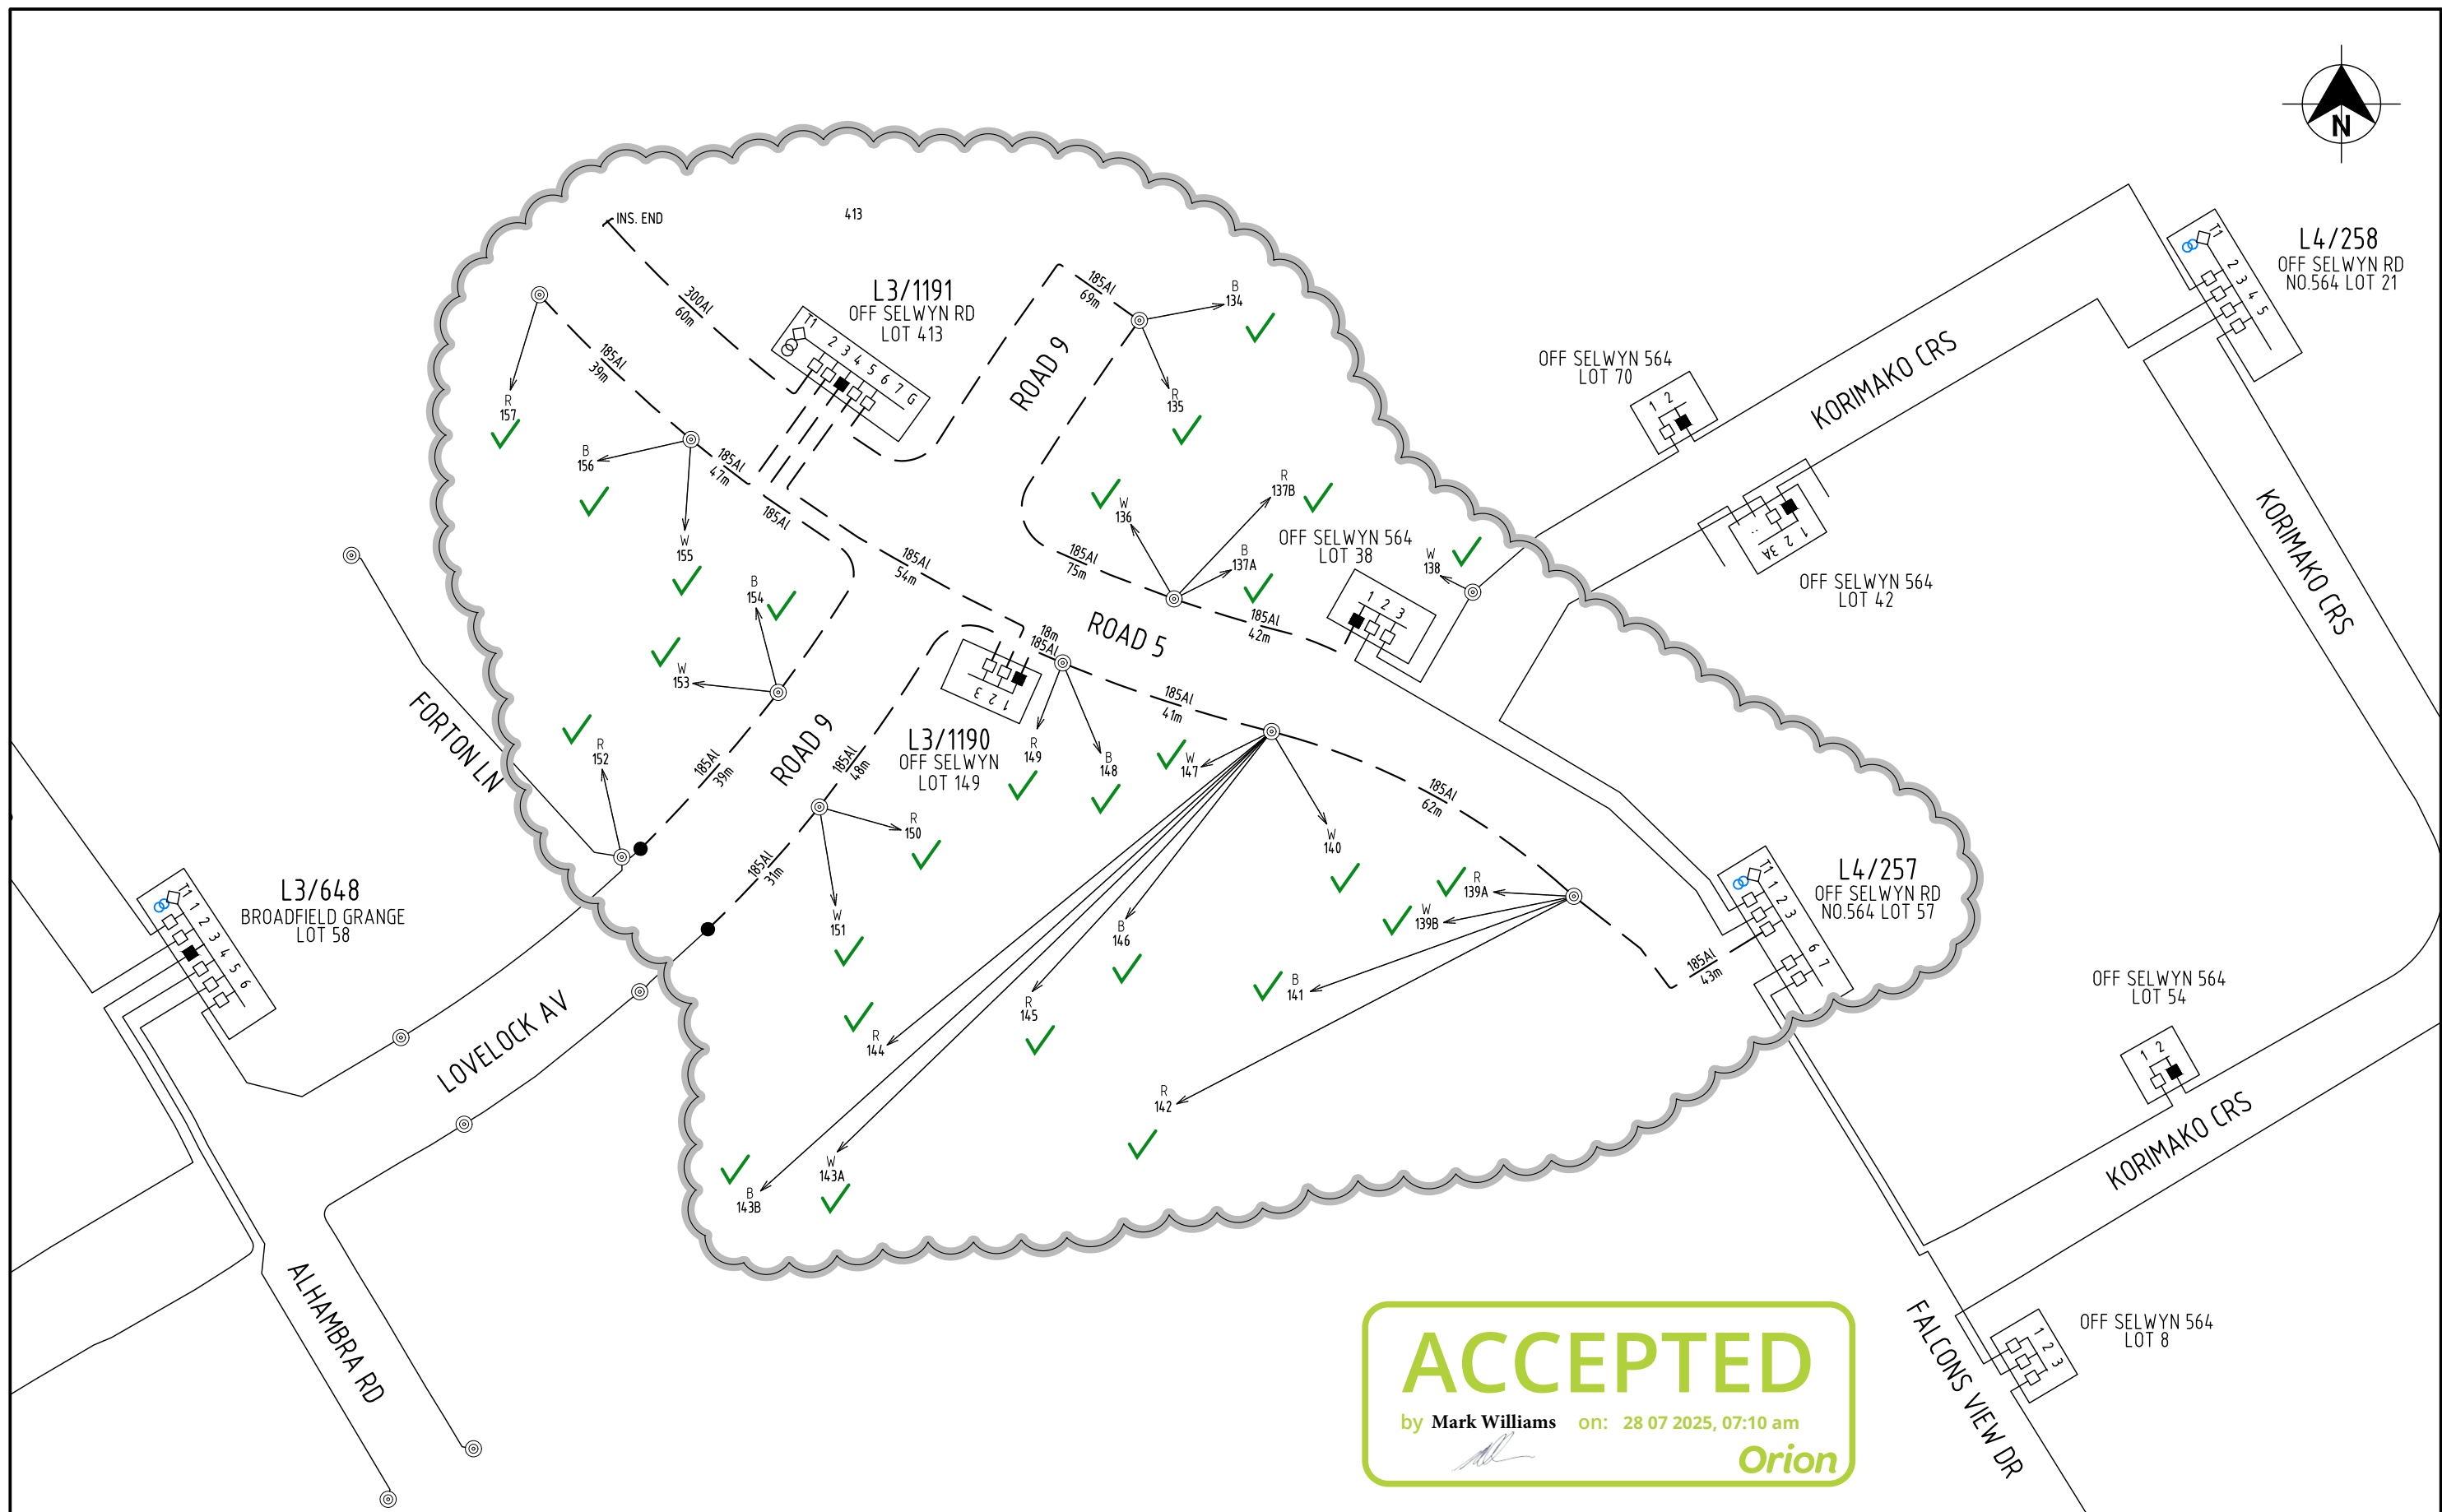

ISSUE	DESCRIPTION	DATE	DESIGN	DRAWN	CHECKD	TASK	NAME	SIGNATURE	DATED	BROADFIELD GRANGE STAGE 10			 ALLWAYS CONNECTING		
A	ORIGINAL ISSUE	02/07/25	A.M.	A.M.	N.J.	DESIGNED	A. MECHEN		30/05/25						
						DRAWN	A. MECHEN		30/05/25	24 LOT RESIDENTIAL SUBDIVISION LV SCHEMATICS - PROPOSED			SCALE(SIZE)	DRAWING NO.	SHEET
						CHECKED	N. JARRETT		02/07/25				NTS (A3)	106908	S10-LV-2
						APPROVED									
						ORN101904.9	 CONNETICS LIMITED. ALL RIGHTS RESERVED UNAUTHORISED USE PROHIBITED		A						




ISSUE	DESCRIPTION	DATE	DESIGN	DRAWN	CHECKD	TASK	NAME	SIGNATURE	DATED
A	ORIGINAL ISSUE	02/07/25	A.M.	A.M.	N.J.	DESIGNED	A. MECHEN		30/05/25
						DRAWN	A. MECHEN		30/05/25
						CHECKED	N. JARRETT		02/07/25
						APPROVED			
						ORN101904.9	CONNETICS LIMITED. ALL RIGHTS RESERVED UNAUTHORISED USE PROHIBITED		A

BROADFIELD GRANGE STAGE 10

24 LOT RESIDENTIAL SUBDIVISION
SL SCHEMATICS - EXISTING



SCALE(SIZE)	DRAWING NO.	SHEET
NTS (A3)	106908	S10-SL-1

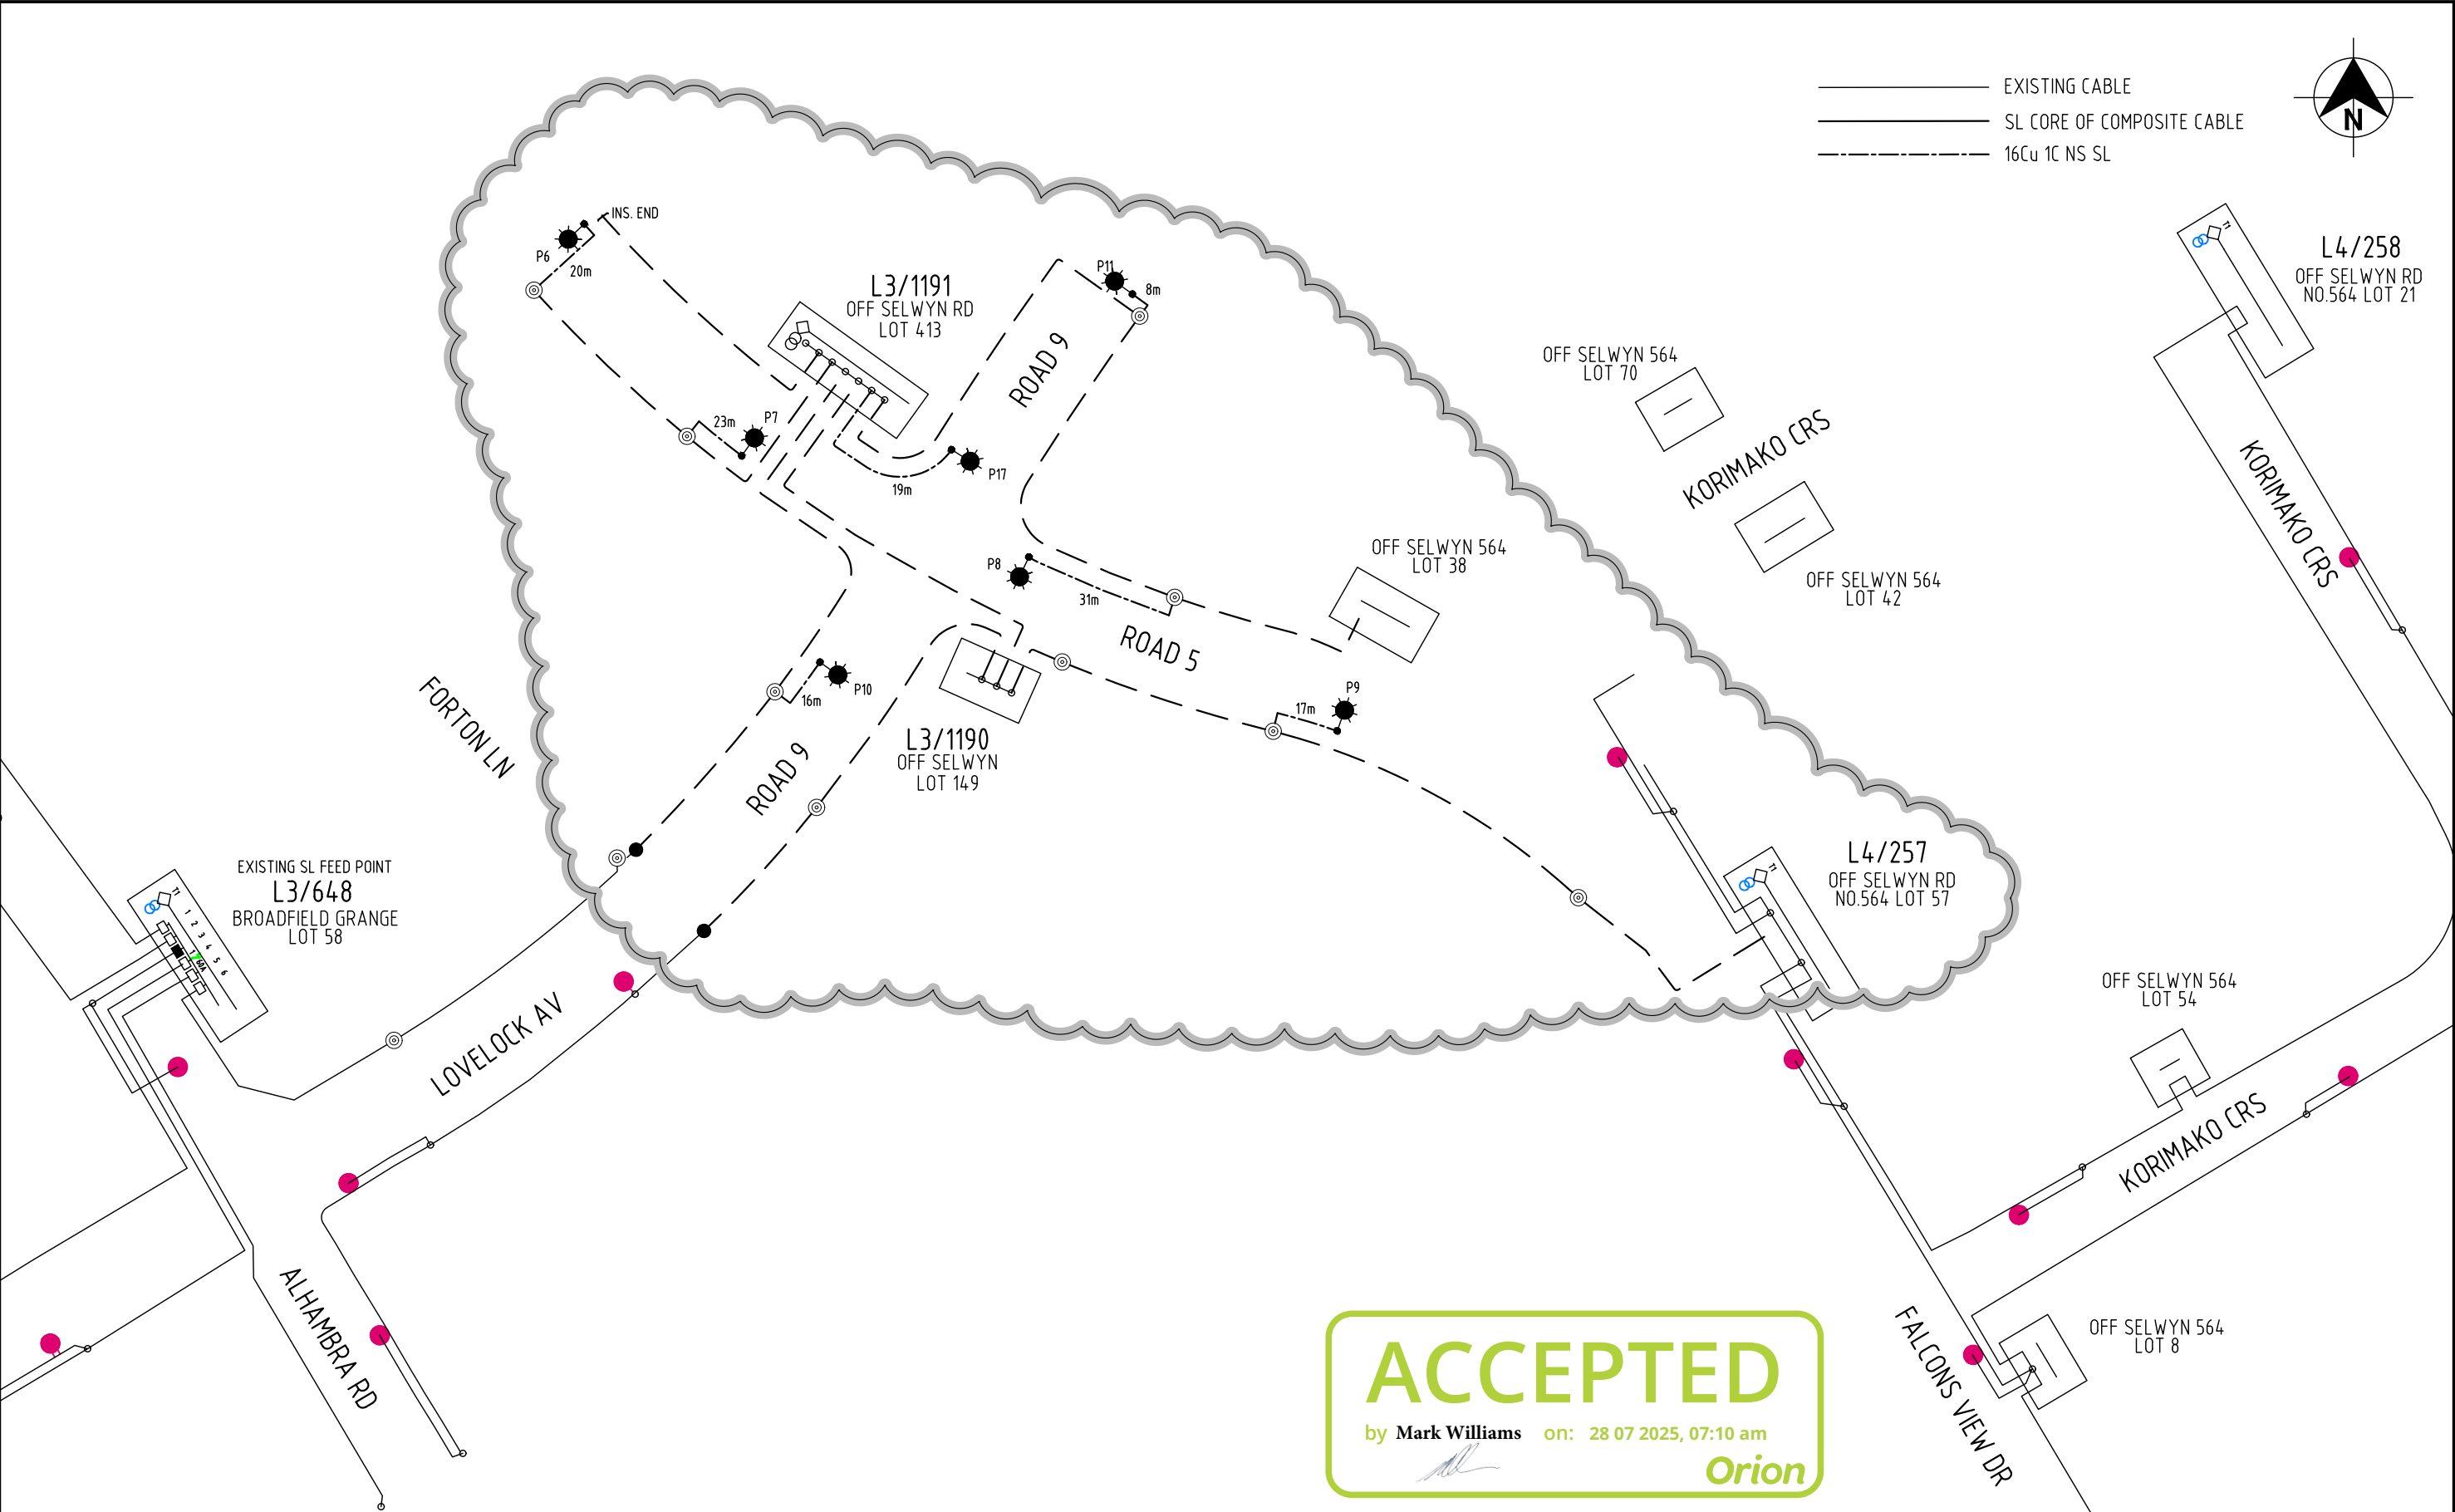


ISSUE	DESCRIPTION	DATE	DESIGN	DRAWN	CHECKD	TASK	NAME	SIGNATURE	DATED
A	ORIGINAL ISSUE	02/07/25	A.M.	A.M.	N.J.	DESIGNED	A. MECHEN		30/05/25
						DRAWN	A. MECHEN		30/05/25
						CHECKED	N. JARRETT		02/07/25
						APPROVED			
						ORN101904.9	CONNETICS LIMITED. ALL RIGHTS RESERVED UNAUTHORISED USE PROHIBITED		A

BROADFIELD GRANGE STAGE 10

24 LOT RESIDENTIAL SUBDIVISION
SL SCHEMATICS - PROPOSED




SCALE(SIZE)	DRAWING NO.	SHEET
NTS (A3)	106908	S10-SL-2

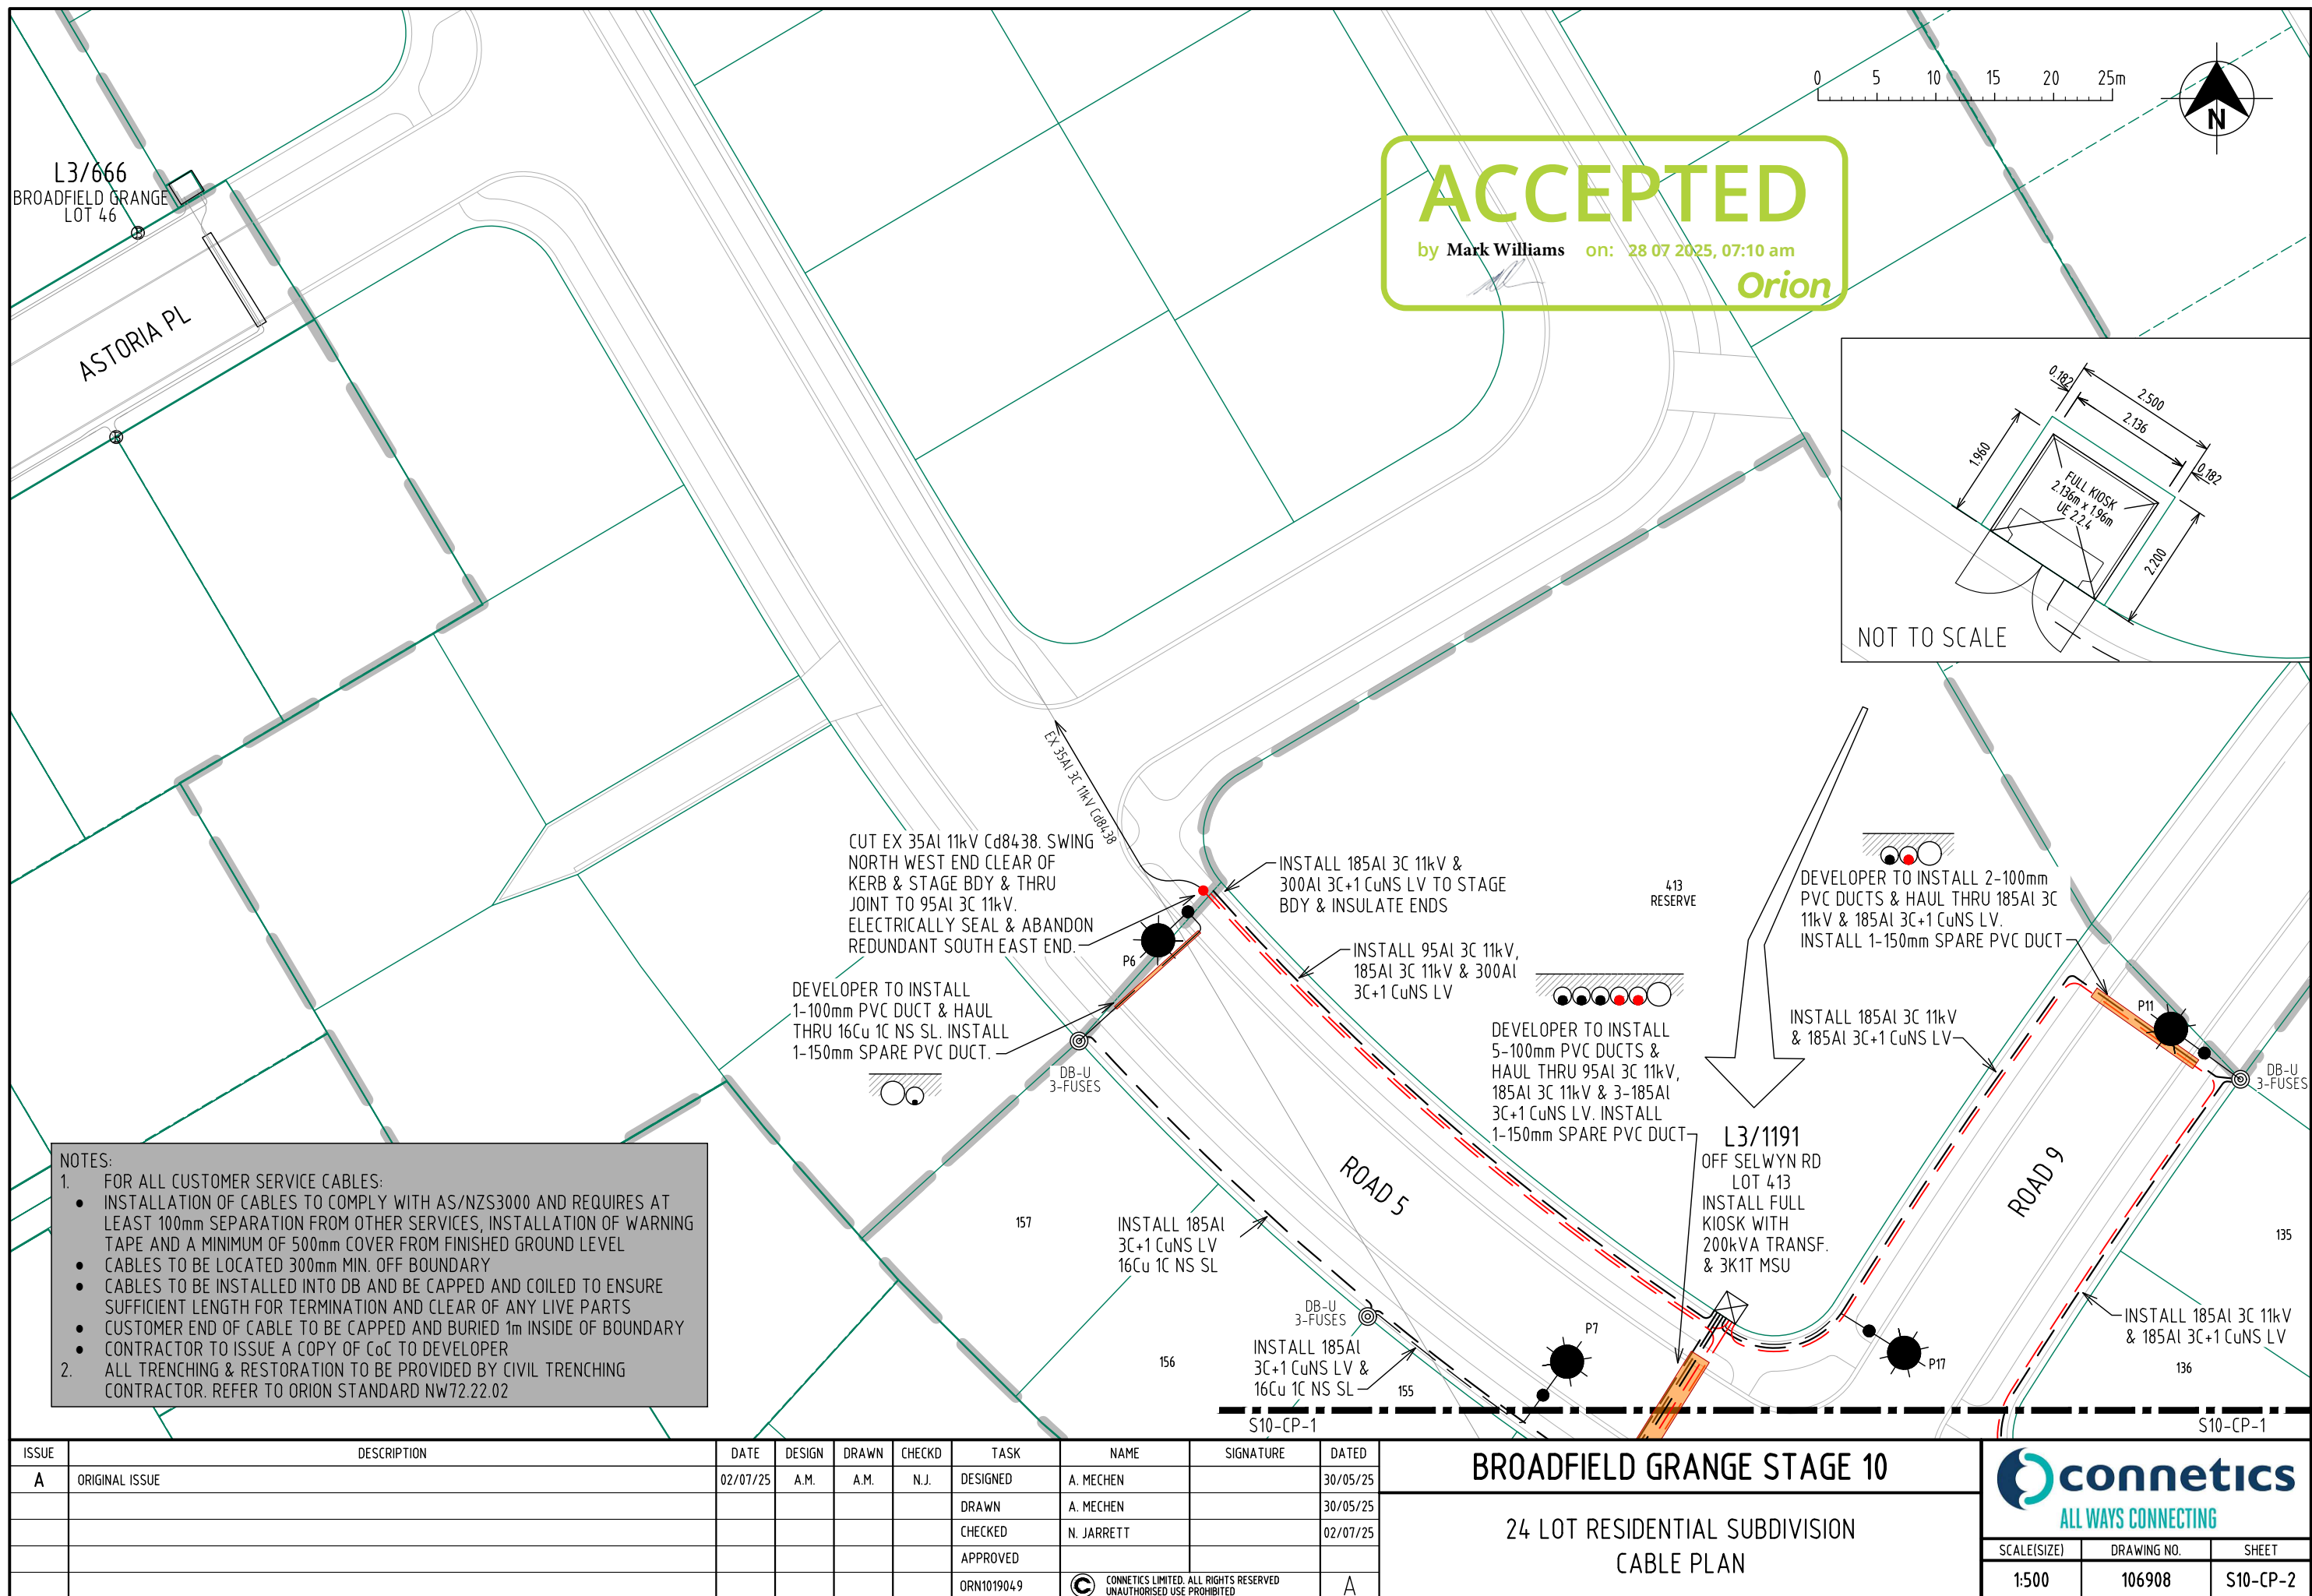

- NOTES:
- FOR ALL CUSTOMER SERVICE CABLES:
 - INSTALLATION OF CABLES TO COMPLY WITH AS/NZS3000 AND REQUIRES AT LEAST 100mm SEPARATION FROM OTHER SERVICES, INSTALLATION OF WARNING TAPE AND A MINIMUM OF 500mm COVER FROM FINISHED GROUND LEVEL
 - CABLES TO BE LOCATED 300mm MIN. OFF BOUNDARY
 - CABLES TO BE INSTALLED INTO DB AND BE CAPPED AND COILED TO ENSURE SUFFICIENT LENGTH FOR TERMINATION AND CLEAR OF ANY LIVE PARTS
 - CUSTOMER END OF CABLE TO BE CAPPED AND BURIED 1m INSIDE OF BOUNDARY
 - CONTRACTOR TO ISSUE A COPY OF CoC TO DEVELOPER
 - ALL TRENCHING & RESTORATION TO BE PROVIDED BY CIVIL TRENCHING CONTRACTOR. REFER TO ORION STANDARD NW72.22.02

ISSUE	DESCRIPTION	DATE	DESIGN	DRAWN	CHECKD	TASK	NAME	SIGNATURE	DATED	BROADFIELD GRANGE STAGE 10			 ALL WAYS CONNECTING			
A	ORIGINAL ISSUE	02/07/25	A.M.	A.M.	N.J.	DESIGNED	A. MECHE		30/05/25					SCALE(SIZE)		
						DRAWN	A. MECHE		30/05/25	24 LOT RESIDENTIAL SUBDIVISION CABLE PLAN				1:500	106908	S10-CP-2
						CHECKED	N. JARRETT		02/07/25							
						APPROVED										
						ORN101904.9	 CONNETICS LIMITED. ALL RIGHTS RESERVED UNAUTHORISED USE PROHIBITED		A							

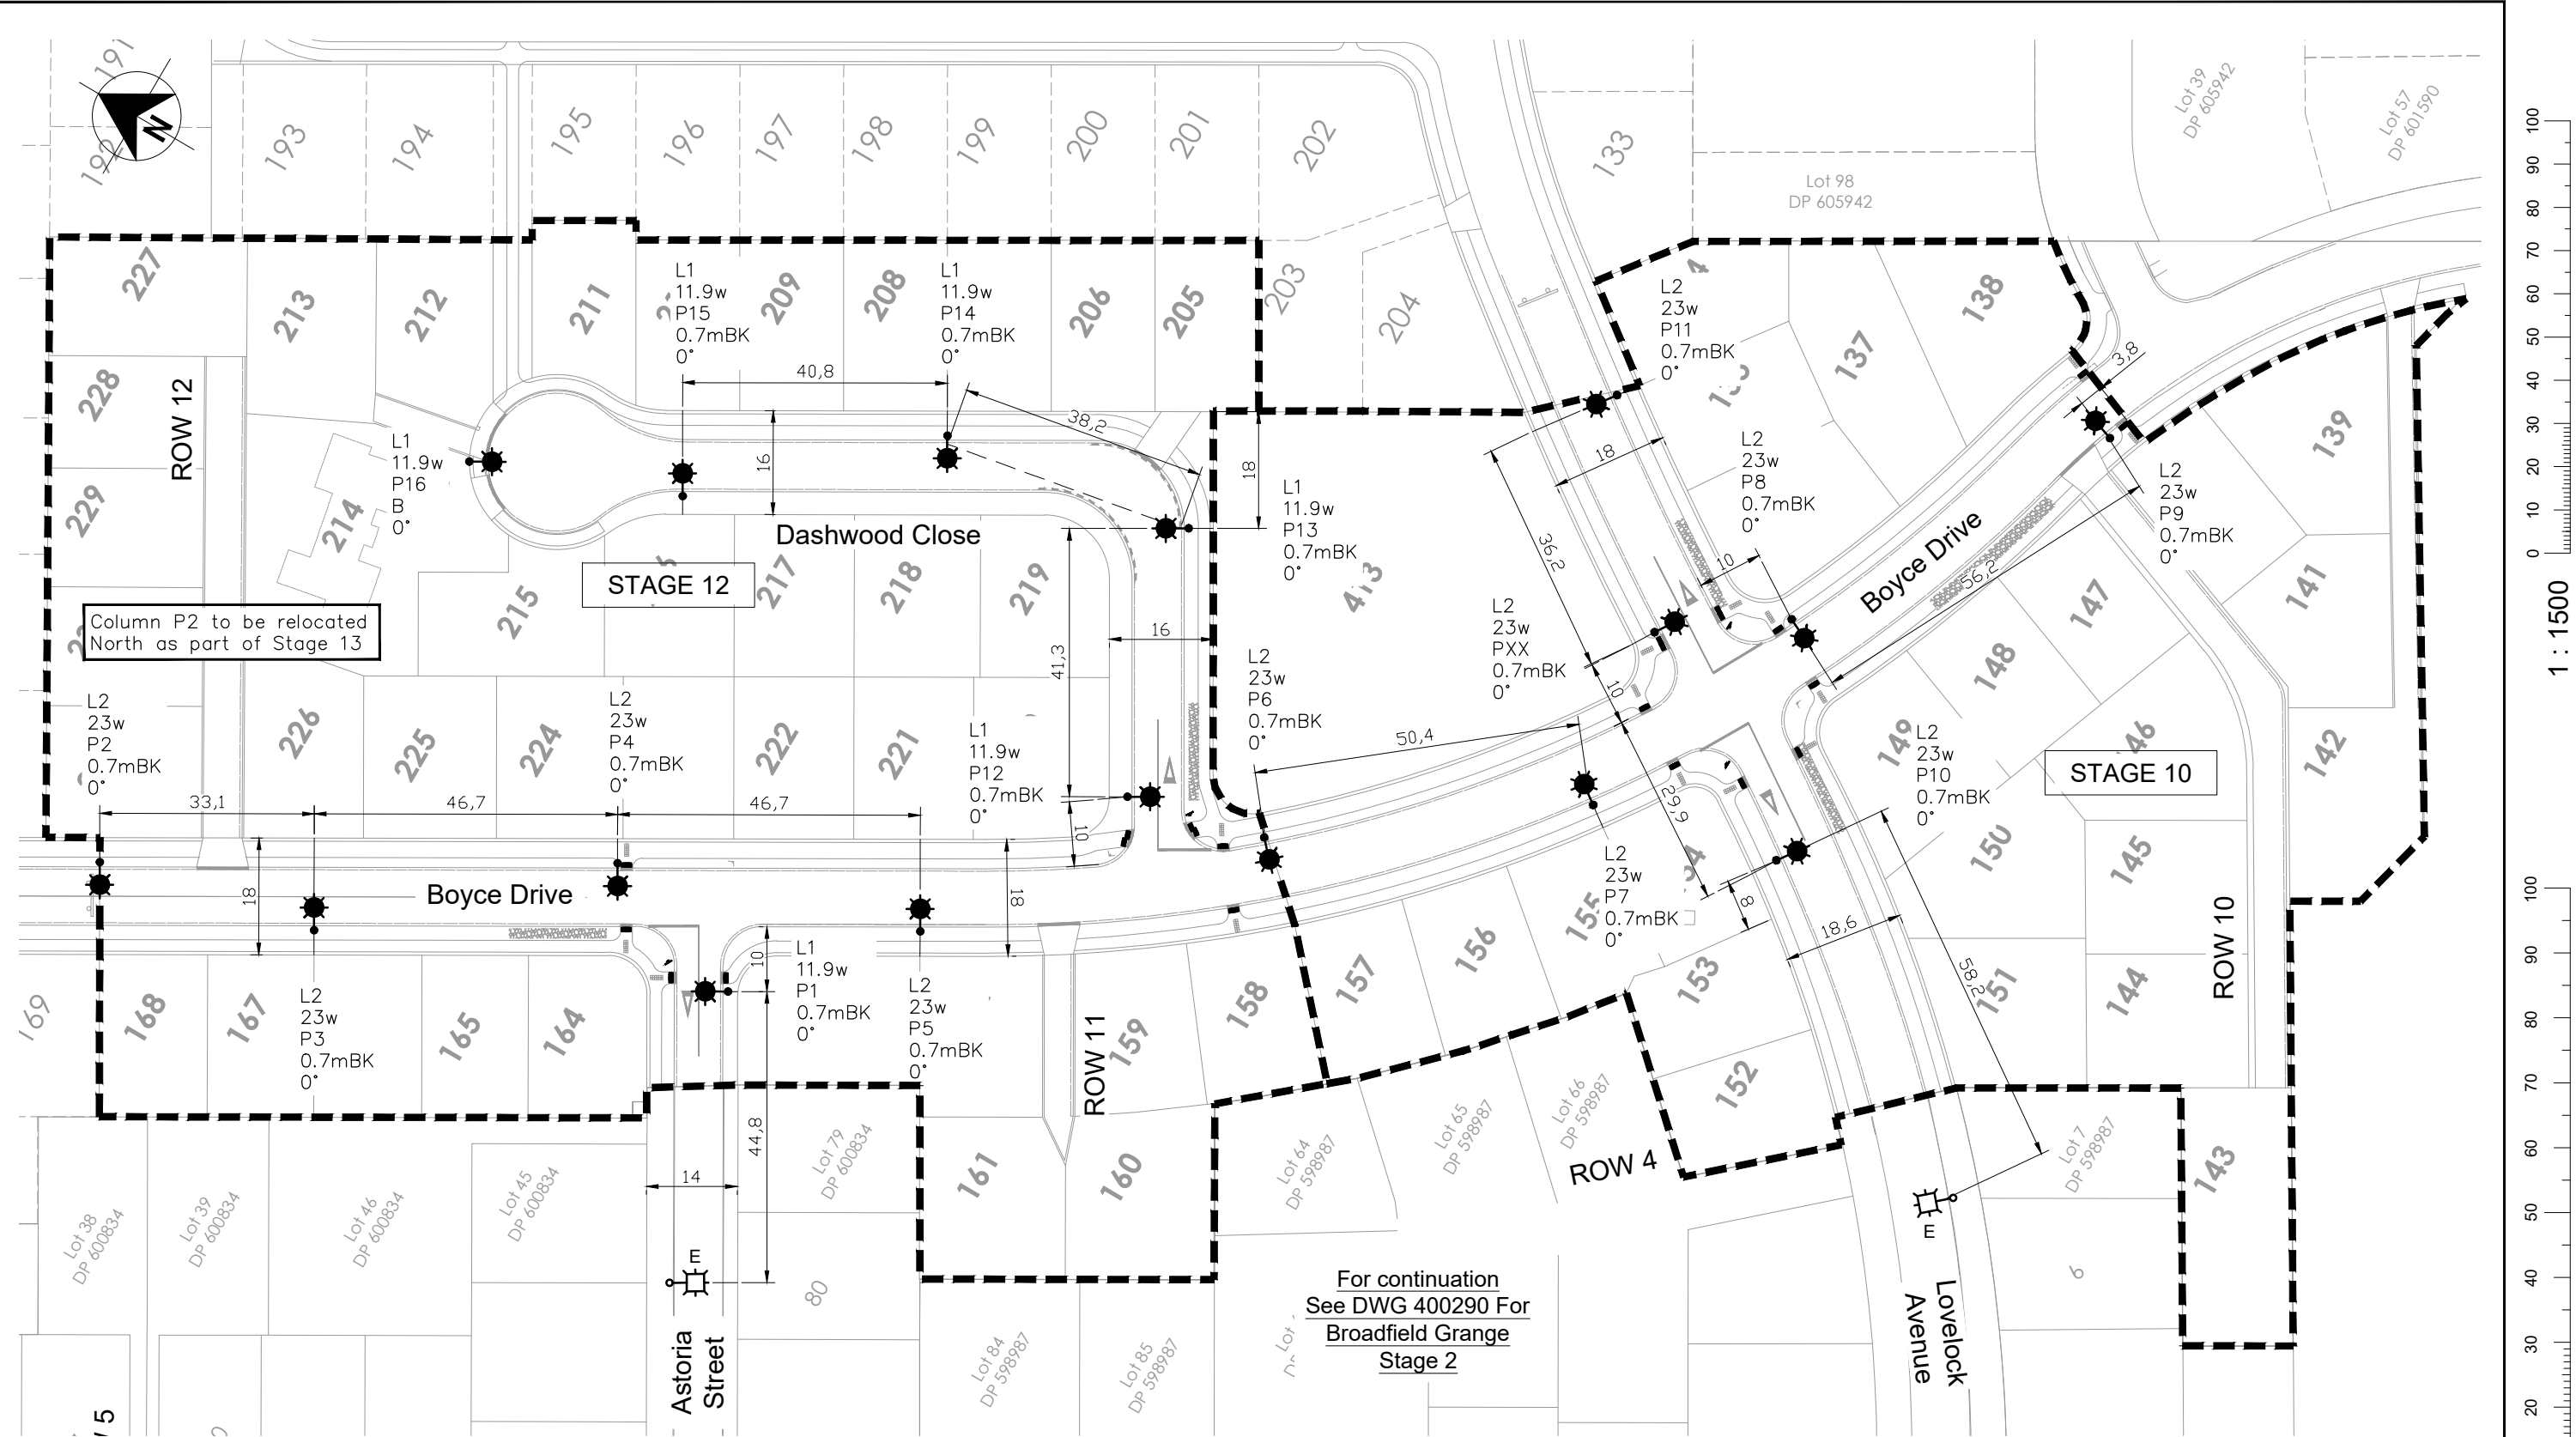

Column P2 to be relocated North as part of Stage 13

STAGE 12

STAGE 10

For continuation
See DWG 400290 For
Broadfield Grange
Stage 2

NOTES:

- 1. Refer to Sheet 1 for Luminaire Schedule and Legend.

ISSUED FOR INFORMATION
Friday, 16 May 2025 10:29:24 am
NOT FOR CONSTRUCTION



WINDSOR URBAN LTD.
ALL RIGHTS RESERVED.
UNAUTHORISED USE PROHIBITED

Rev	Description	Date	Des	Dn	Chk	Apd	Or Acp	Contractor	Designed	R. St-Denis / Conn	May 25	Scale
A	Issued to Client for Comments	16/05/25	RSD	RSD	-	-	-	-	Drawn	R. St-Denis / Conn	May 25	1:1000
									Checked	J. Lim / Conn	-	
									Approved	B. Hayman for SDC	-	
									Connetics	-	-	
												Revision
												A

STREETLIGHTING LAYOUT

Broadfield Grange Sub-Division
Phase 2 - Stage 10 & 12
East Rolleston



windsorurban
LIGHTING FURNITURE


611 Halswell Junction Rd, Hornby, Christchurch, NZ
Phone: (03) 349-7653 Fax: (03) 349-6529 Freephone: (0800) 845-845
Email: info@windsorurban.co.nz

Size	Drawing Number	Sheet
A3	400386	2 / 2

Designer:	A. Mechen	Date:	2/07/2025
Design number:	106908	Job name:	Broadfield Grange Stage 10
Approx. start date:		Developer:	Urban Estates
Orions Contract		Design/Build:	
Orion Contact		Design Only:	Yes

These quantity estimations are based on the CAD file and are for pricing purposes only. Actual quantities may vary on site.

Stock number	Description	Quantity (m)	Special requirements
1003401	6mm Cu 2ph NS LV	0	
1003402	16mm Cu 1ph NS LV	147	
1003403	16mm Cu 2ph NS LV	0	
1003404	16mm Cu 3ph NS LV	0	
1003405	25mm Cu 1ph NS LV	0	
1003406	25mm Cu 3ph NS LV	0	
1001995	35mm Cu 1ph NS LV	84	
1003407	35mm Cu 3ph NS LV	0	
1008940	70mm Al 1C NS LV	138	
1002009	95mm Al 1C NS LV	319	
1003397	120mm Ali 3ph NS +10mm LV	0	
1003398	185mm Ali 3ph NS +10mm LV	653	
1003399	300mm Ali 3ph NS +10mm LV	61	
1003400	400mm 1c Cu XLPE	0	
1003383	25mm 1c XLPE 11KV	0	
1003384	35mm Ali 3ph XLPE 11KV	0	
1003386	95mm Ali 3ph XLPE 11KV	227	
1003387	185mm Ali 3ph XLPE 11KV	317	
1003390	300mm Ali 3ph XLPE 11KV	0	
1009939	400mm Cu 3ph XLPE 11KV	0	
1003389	185mm 1c Cu 11KV	0	
1006345	95mm 1c AL XLPE 11KV	0	
1003394	300Al 1c 33kV	0	
1003423	25pr 0.9mm PAC PE SWA	0	
1003422	7pr 0.9mm PAC PE SWA	0	
1007115	Distribution Box S - 6 way	0	
1007156	Distribution Box T - 6 way	0	
1012372	DB-U (replaces DB-S & DB-T)	8	
1012376	DB-V (replaces DB-T1)	1	
1001152	Multi Box DC	1	
1000128	Full kiosk	1	
1000129	Half kiosk	0	
1000130	Quarter kiosk	0	

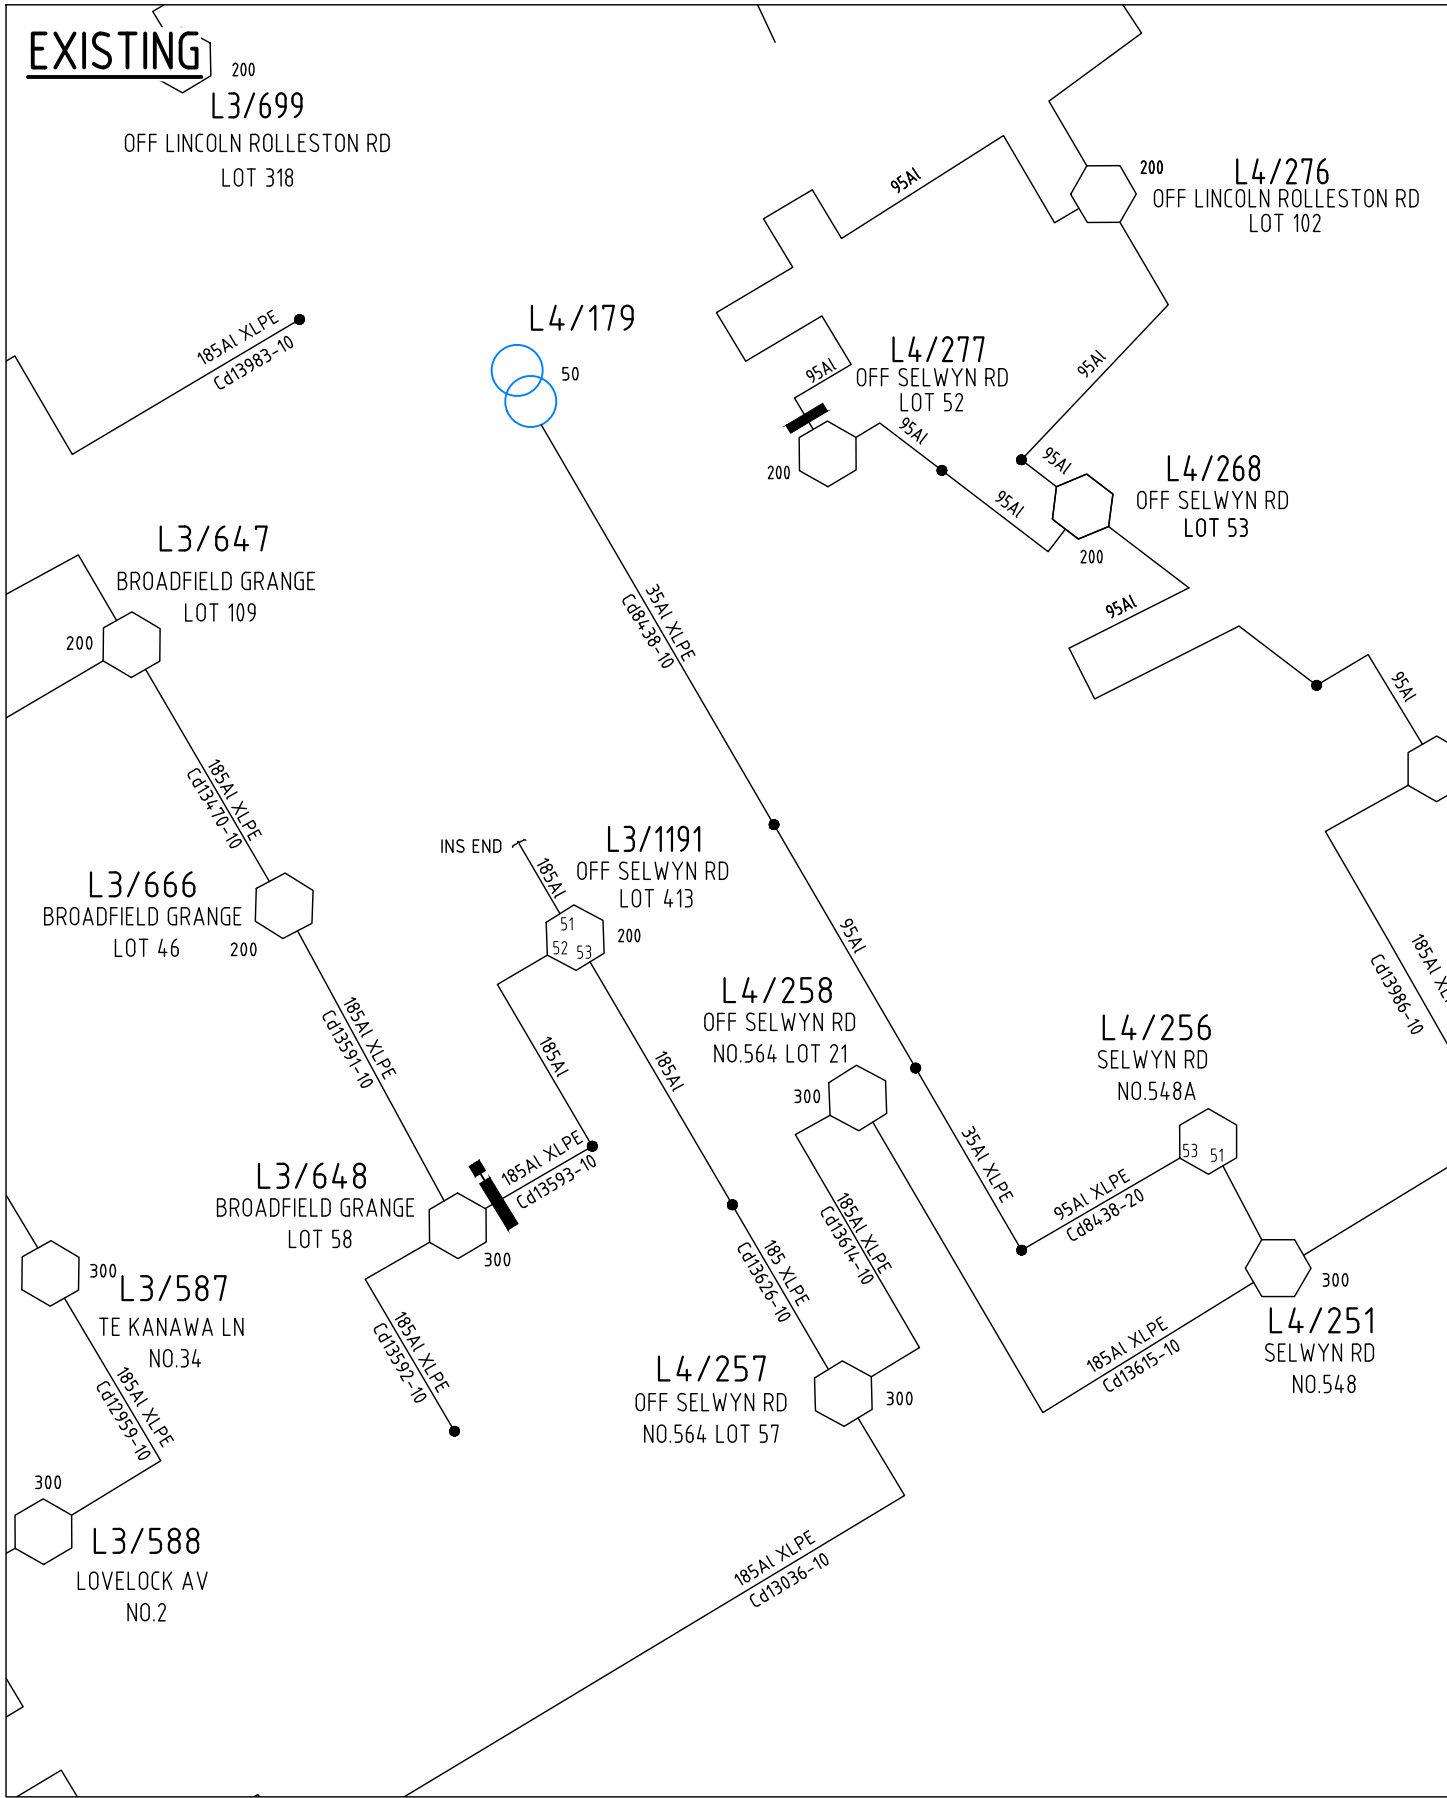


ACCEPTED
by Mark Williams on: 28 07 2025, 08:42 am
Orion

ISSUE	DESCRIPTION	DATE	DESIGN	DRAWN	CHECKD	TASK	NAME	SIGNATURE	DATED
A	ORIGINAL ISSUE	02/07/25	A.M.	A.M.	N.J.	DESIGNED	A. MECHEN		30/05/25
						DRAWN	A. MECHEN		30/05/25
						CHECKED	N. JARRETT		02/07/25
						APPROVED			
						ORN1019050			A

BROADFIELD GRANGE STAGE 12
38 LOT RESIDENTIAL SUBDIVISION
HV SCHEMATICS

 ALL WAYS CONNECTING		
SCALE(SIZE)	DRAWING NO.	SHEET
NTS (A3)	106908	S12-HV-1

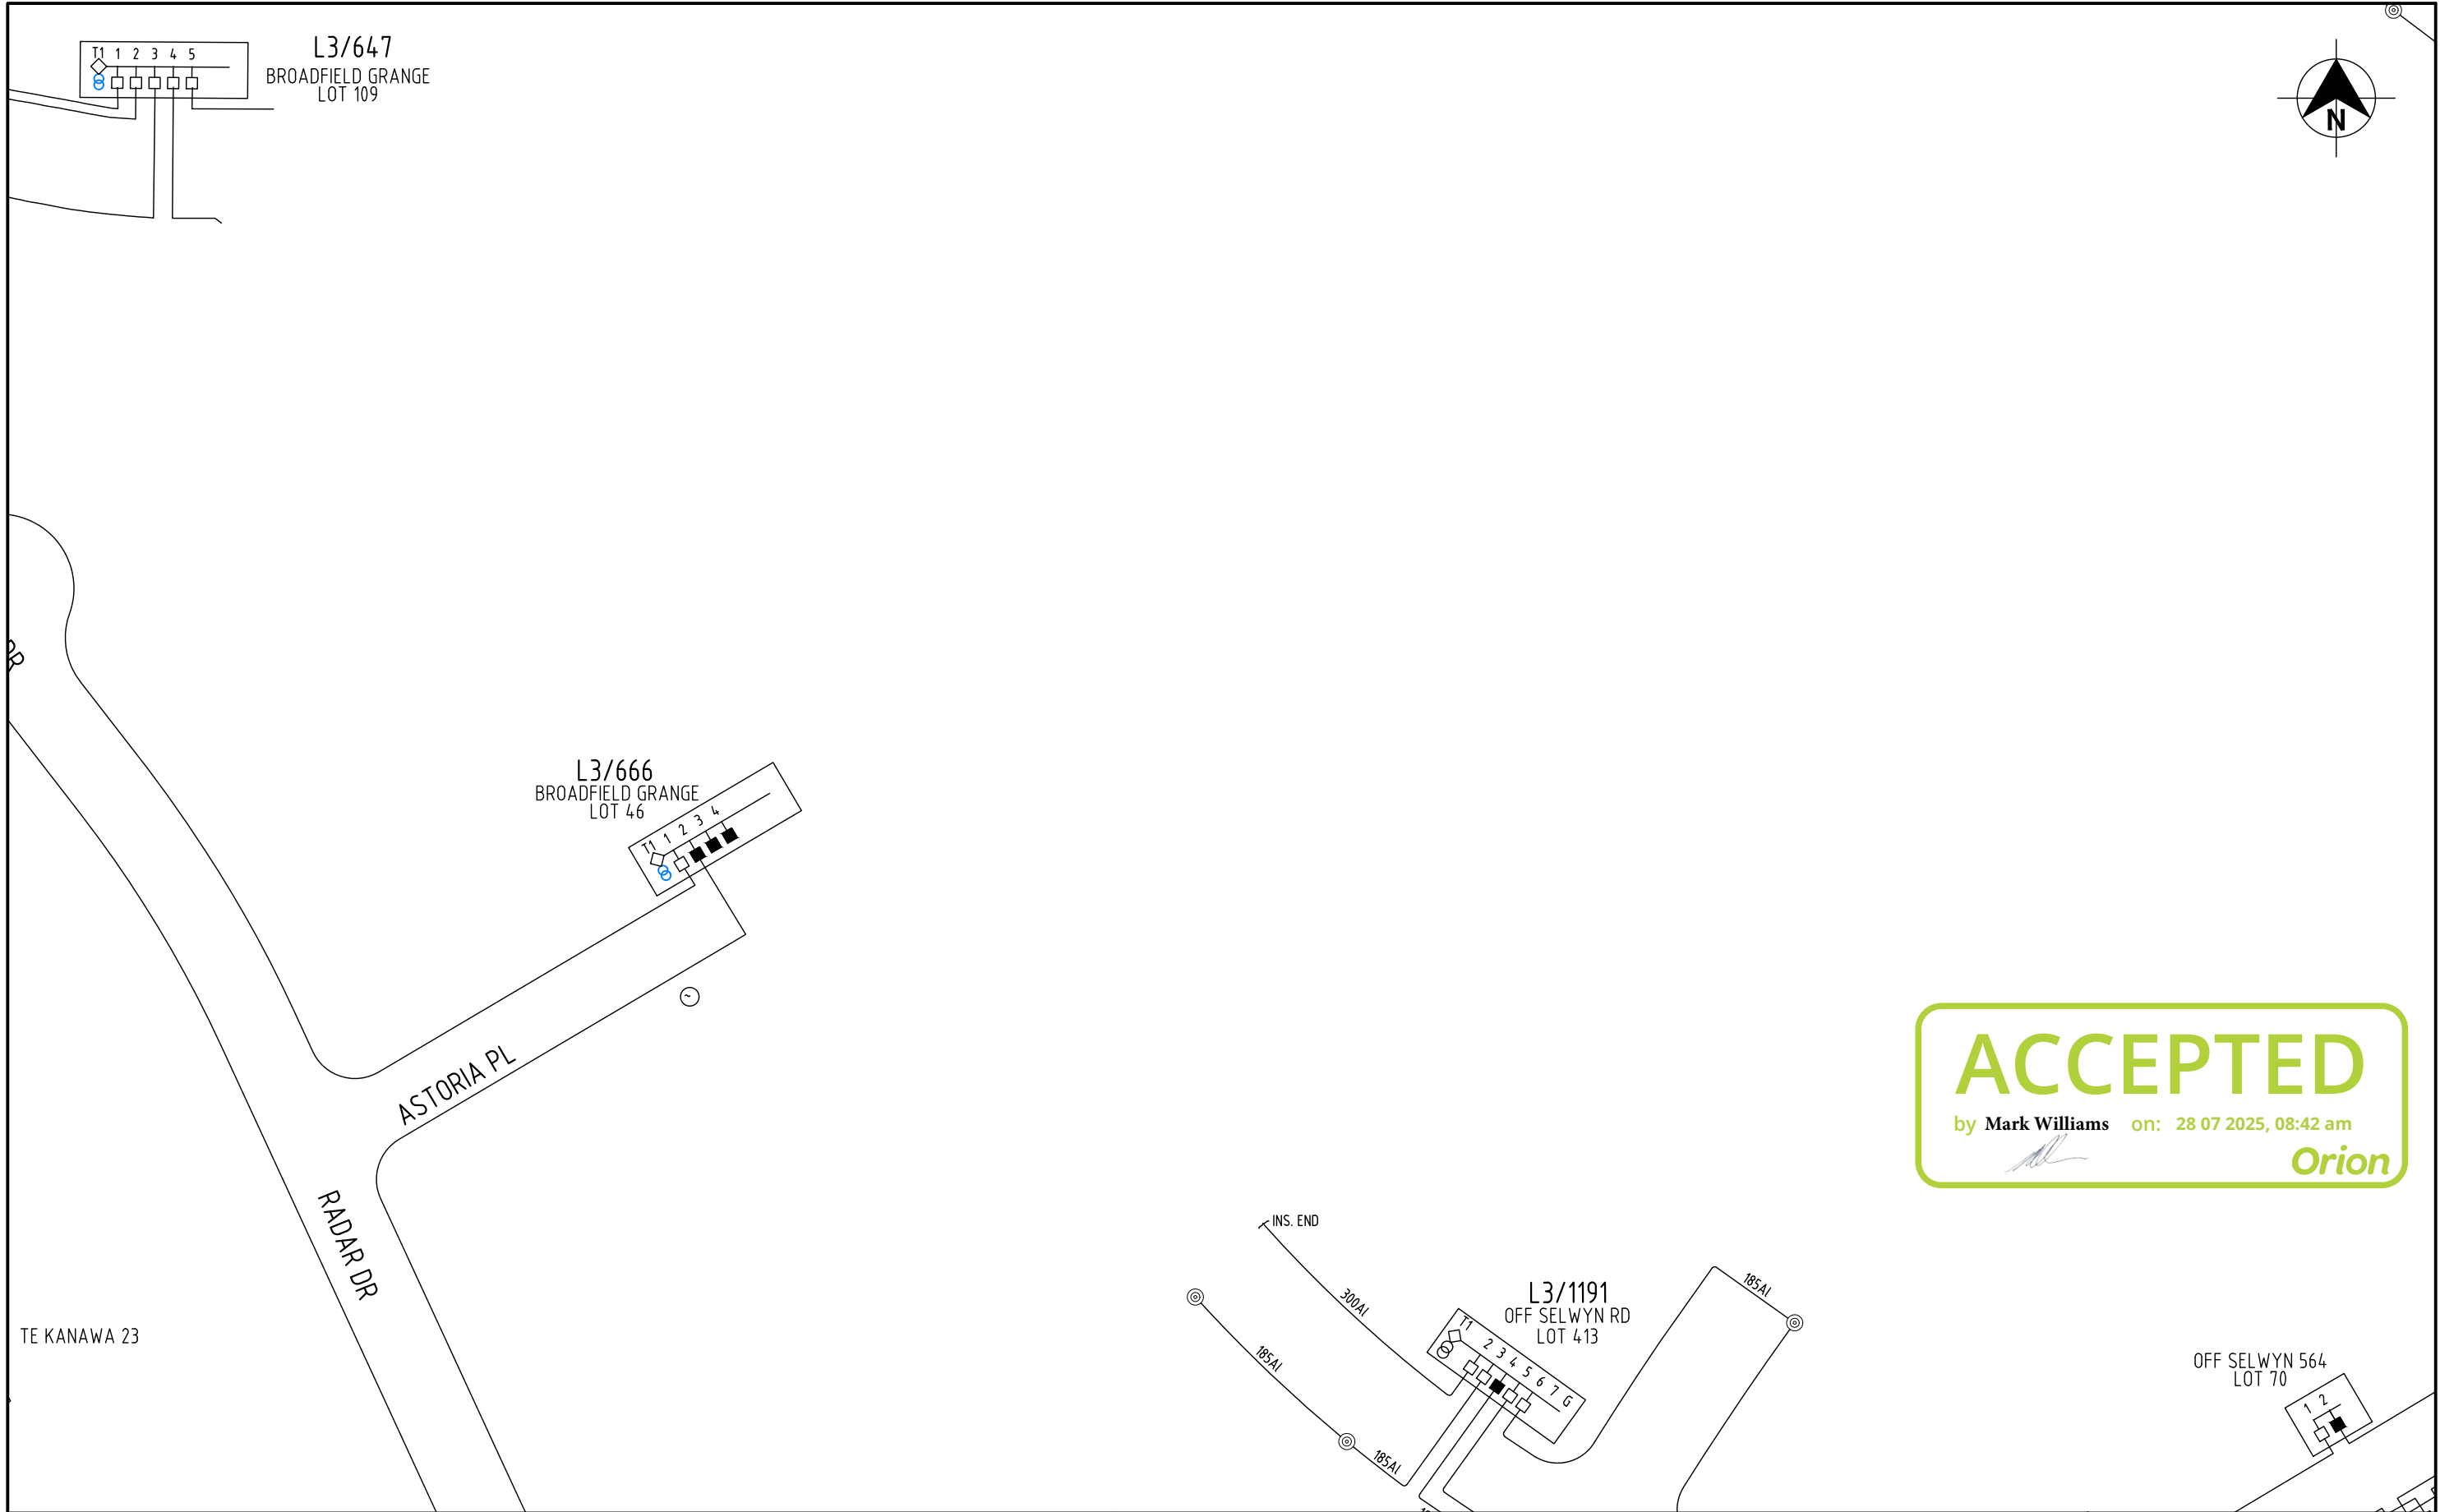


ISSUE	DESCRIPTION	DATE	DESIGN	DRAWN	CHECKD	TASK	NAME	SIGNATURE	DATED
A	ORIGINAL ISSUE	02/07/25	A.M.	A.M.	N.J.	DESIGNED	A. MECHEN		30/05/25
						DRAWN	A. MECHEN		30/05/25
						CHECKED	N. JARRETT		02/07/25
						APPROVED			
						ORN1019050	© CONNETICS LIMITED. ALL RIGHTS RESERVED UNAUTHORISED USE PROHIBITED		A

BROADFIELD GRANGE STAGE 12

38 LOT RESIDENTIAL SUBDIVISION
LV SCHEMATICS - EXISTING



ALL WAYS CONNECTING

SCALE(SIZE)	DRAWING NO.	SHEET
NTS (A3)	106908	S12-LV-1

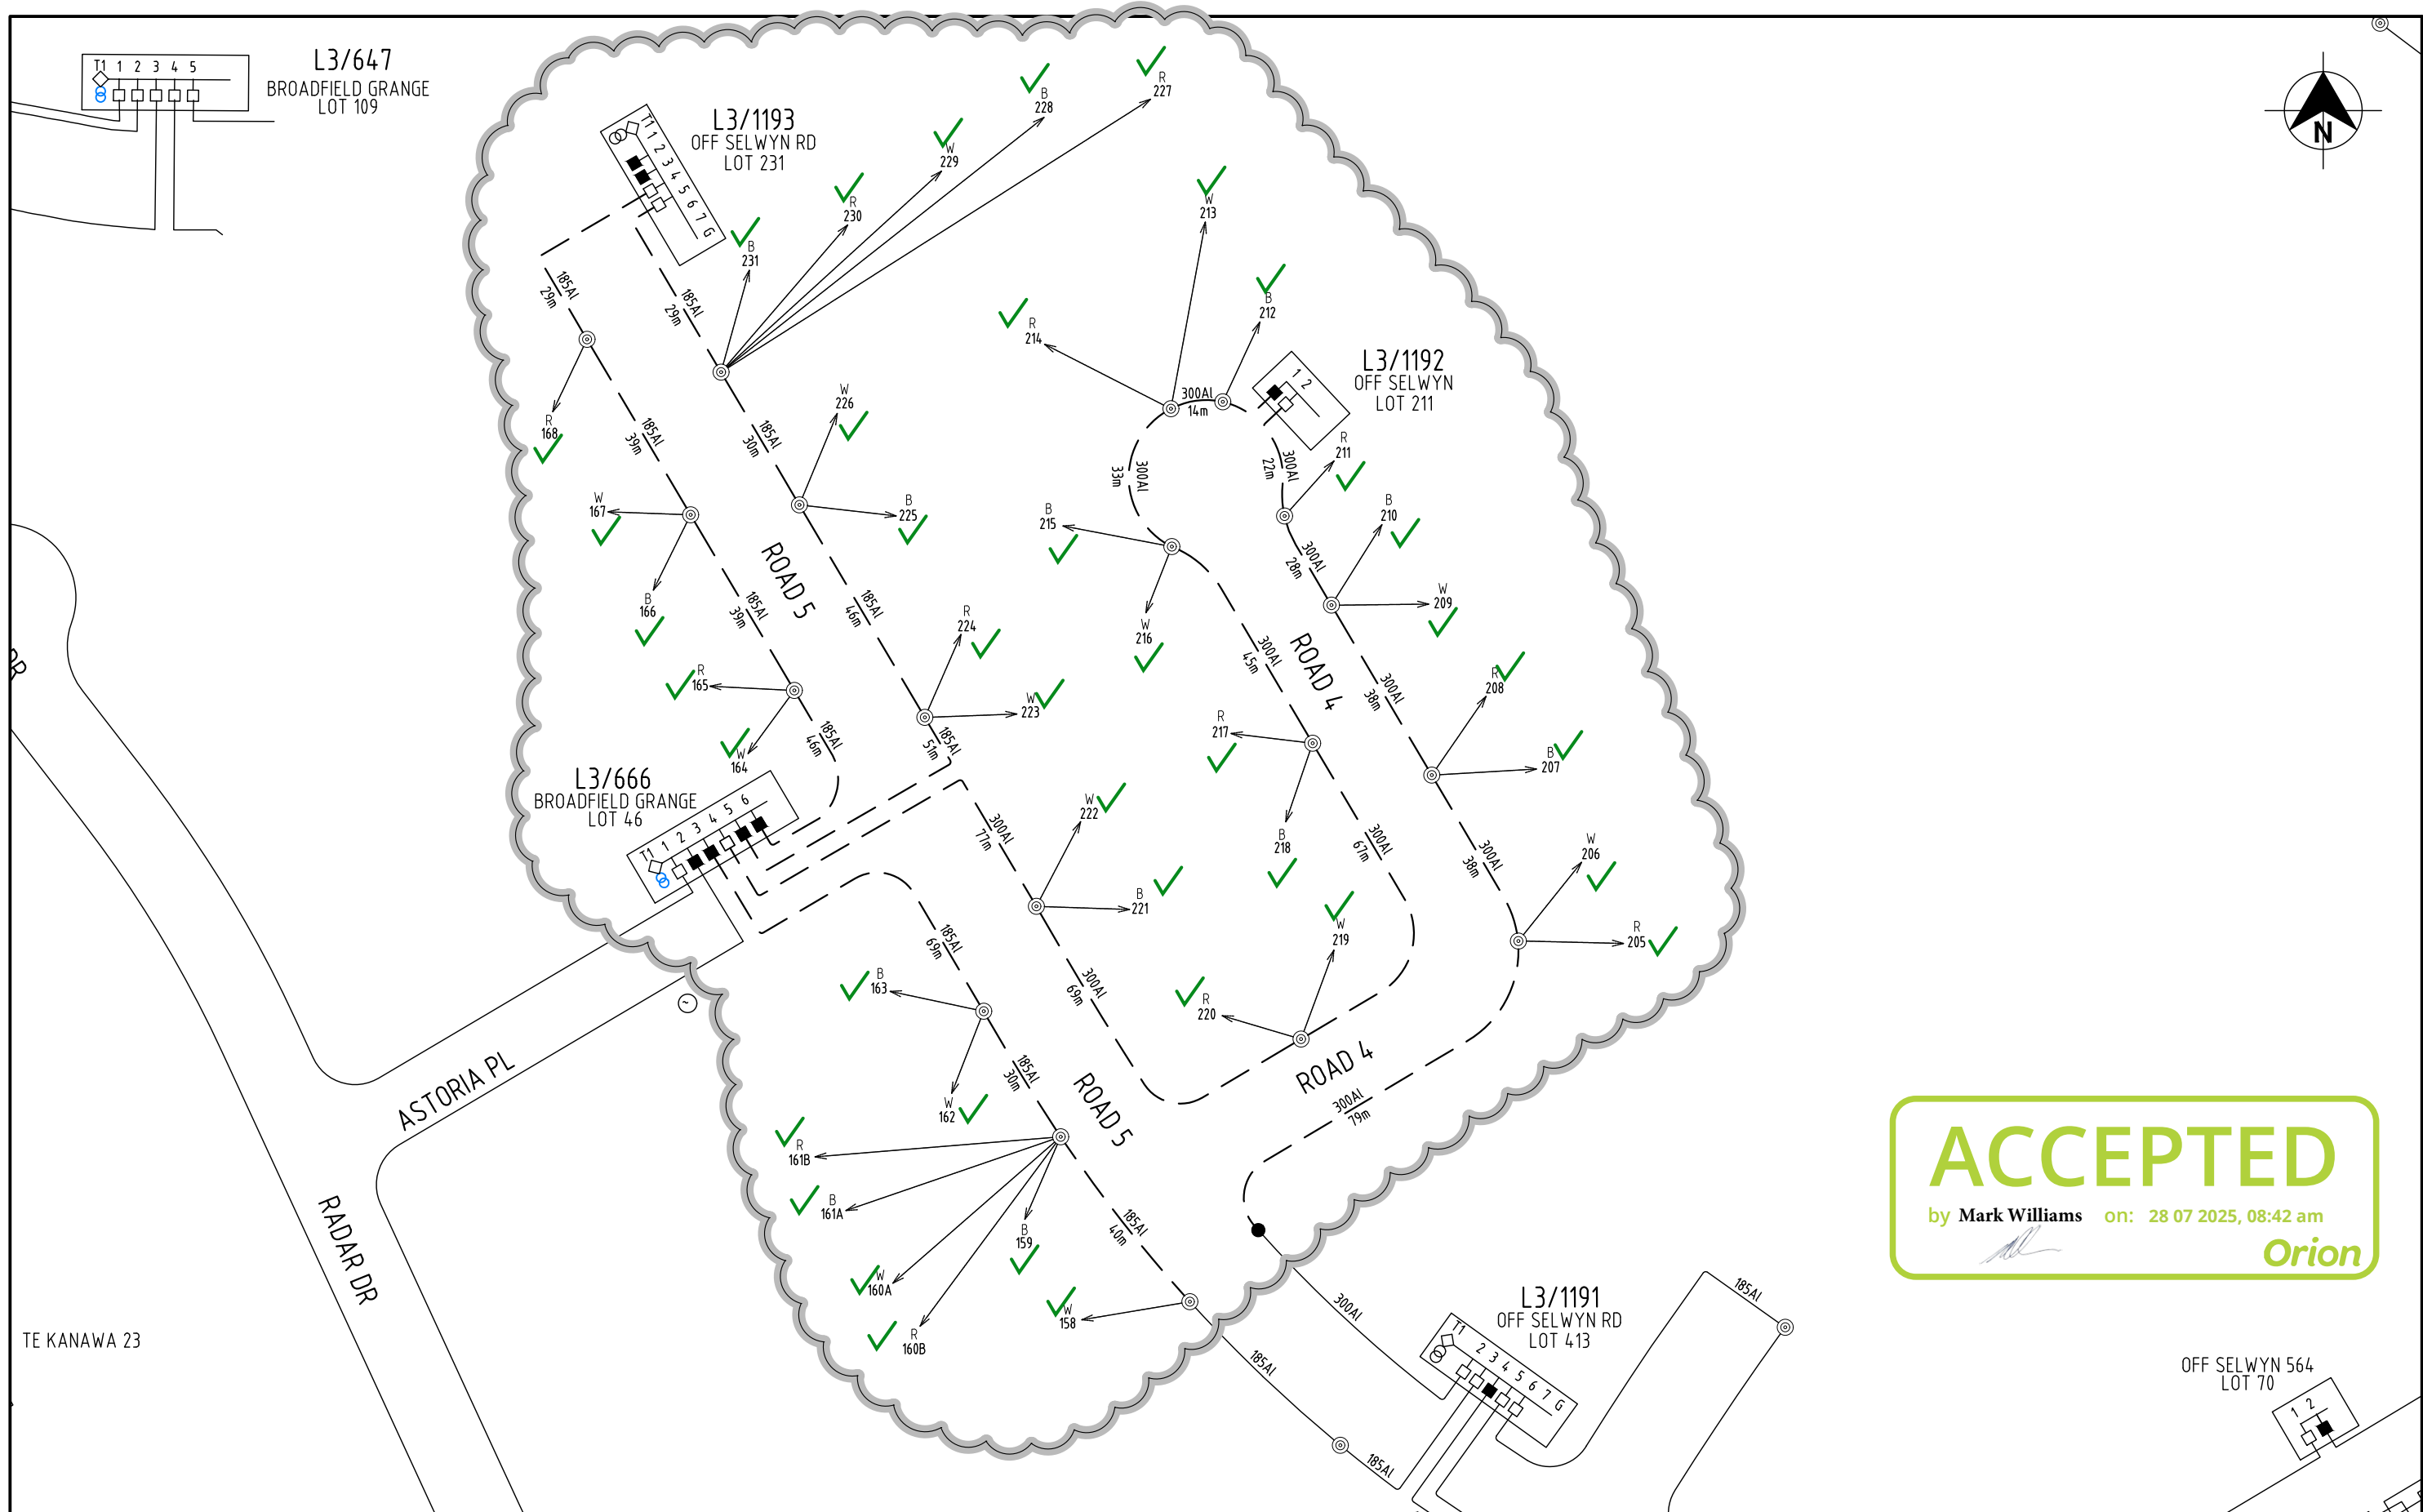


ACCEPTED
by Mark Williams on: 28 07 2025, 08:42 am
Orion

ISSUE	DESCRIPTION	DATE	DESIGN	DRAWN	CHECKD	TASK	NAME	SIGNATURE	DATED	BROADFIELD GRANGE STAGE 12			 ALL WAYS CONNECTING		
A	ORIGINAL ISSUE	02/07/25	A.M.	A.M.	N.J.	DESIGNED	A. MECHEN		30/05/25						
						DRAWN	A. MECHEN		30/05/25						
						CHECKED	N. JARRETT		02/07/25						
						APPROVED									
						ORN1019050	 CONNETICS LIMITED. ALL RIGHTS RESERVED UNAUTHORISED USE PROHIBITED		A						
										 ALL WAYS CONNECTING					
		SCALE(SIZE)		DRAWING NO.		SHEET									
		NTS (A3)		106908		S12-LV-2									

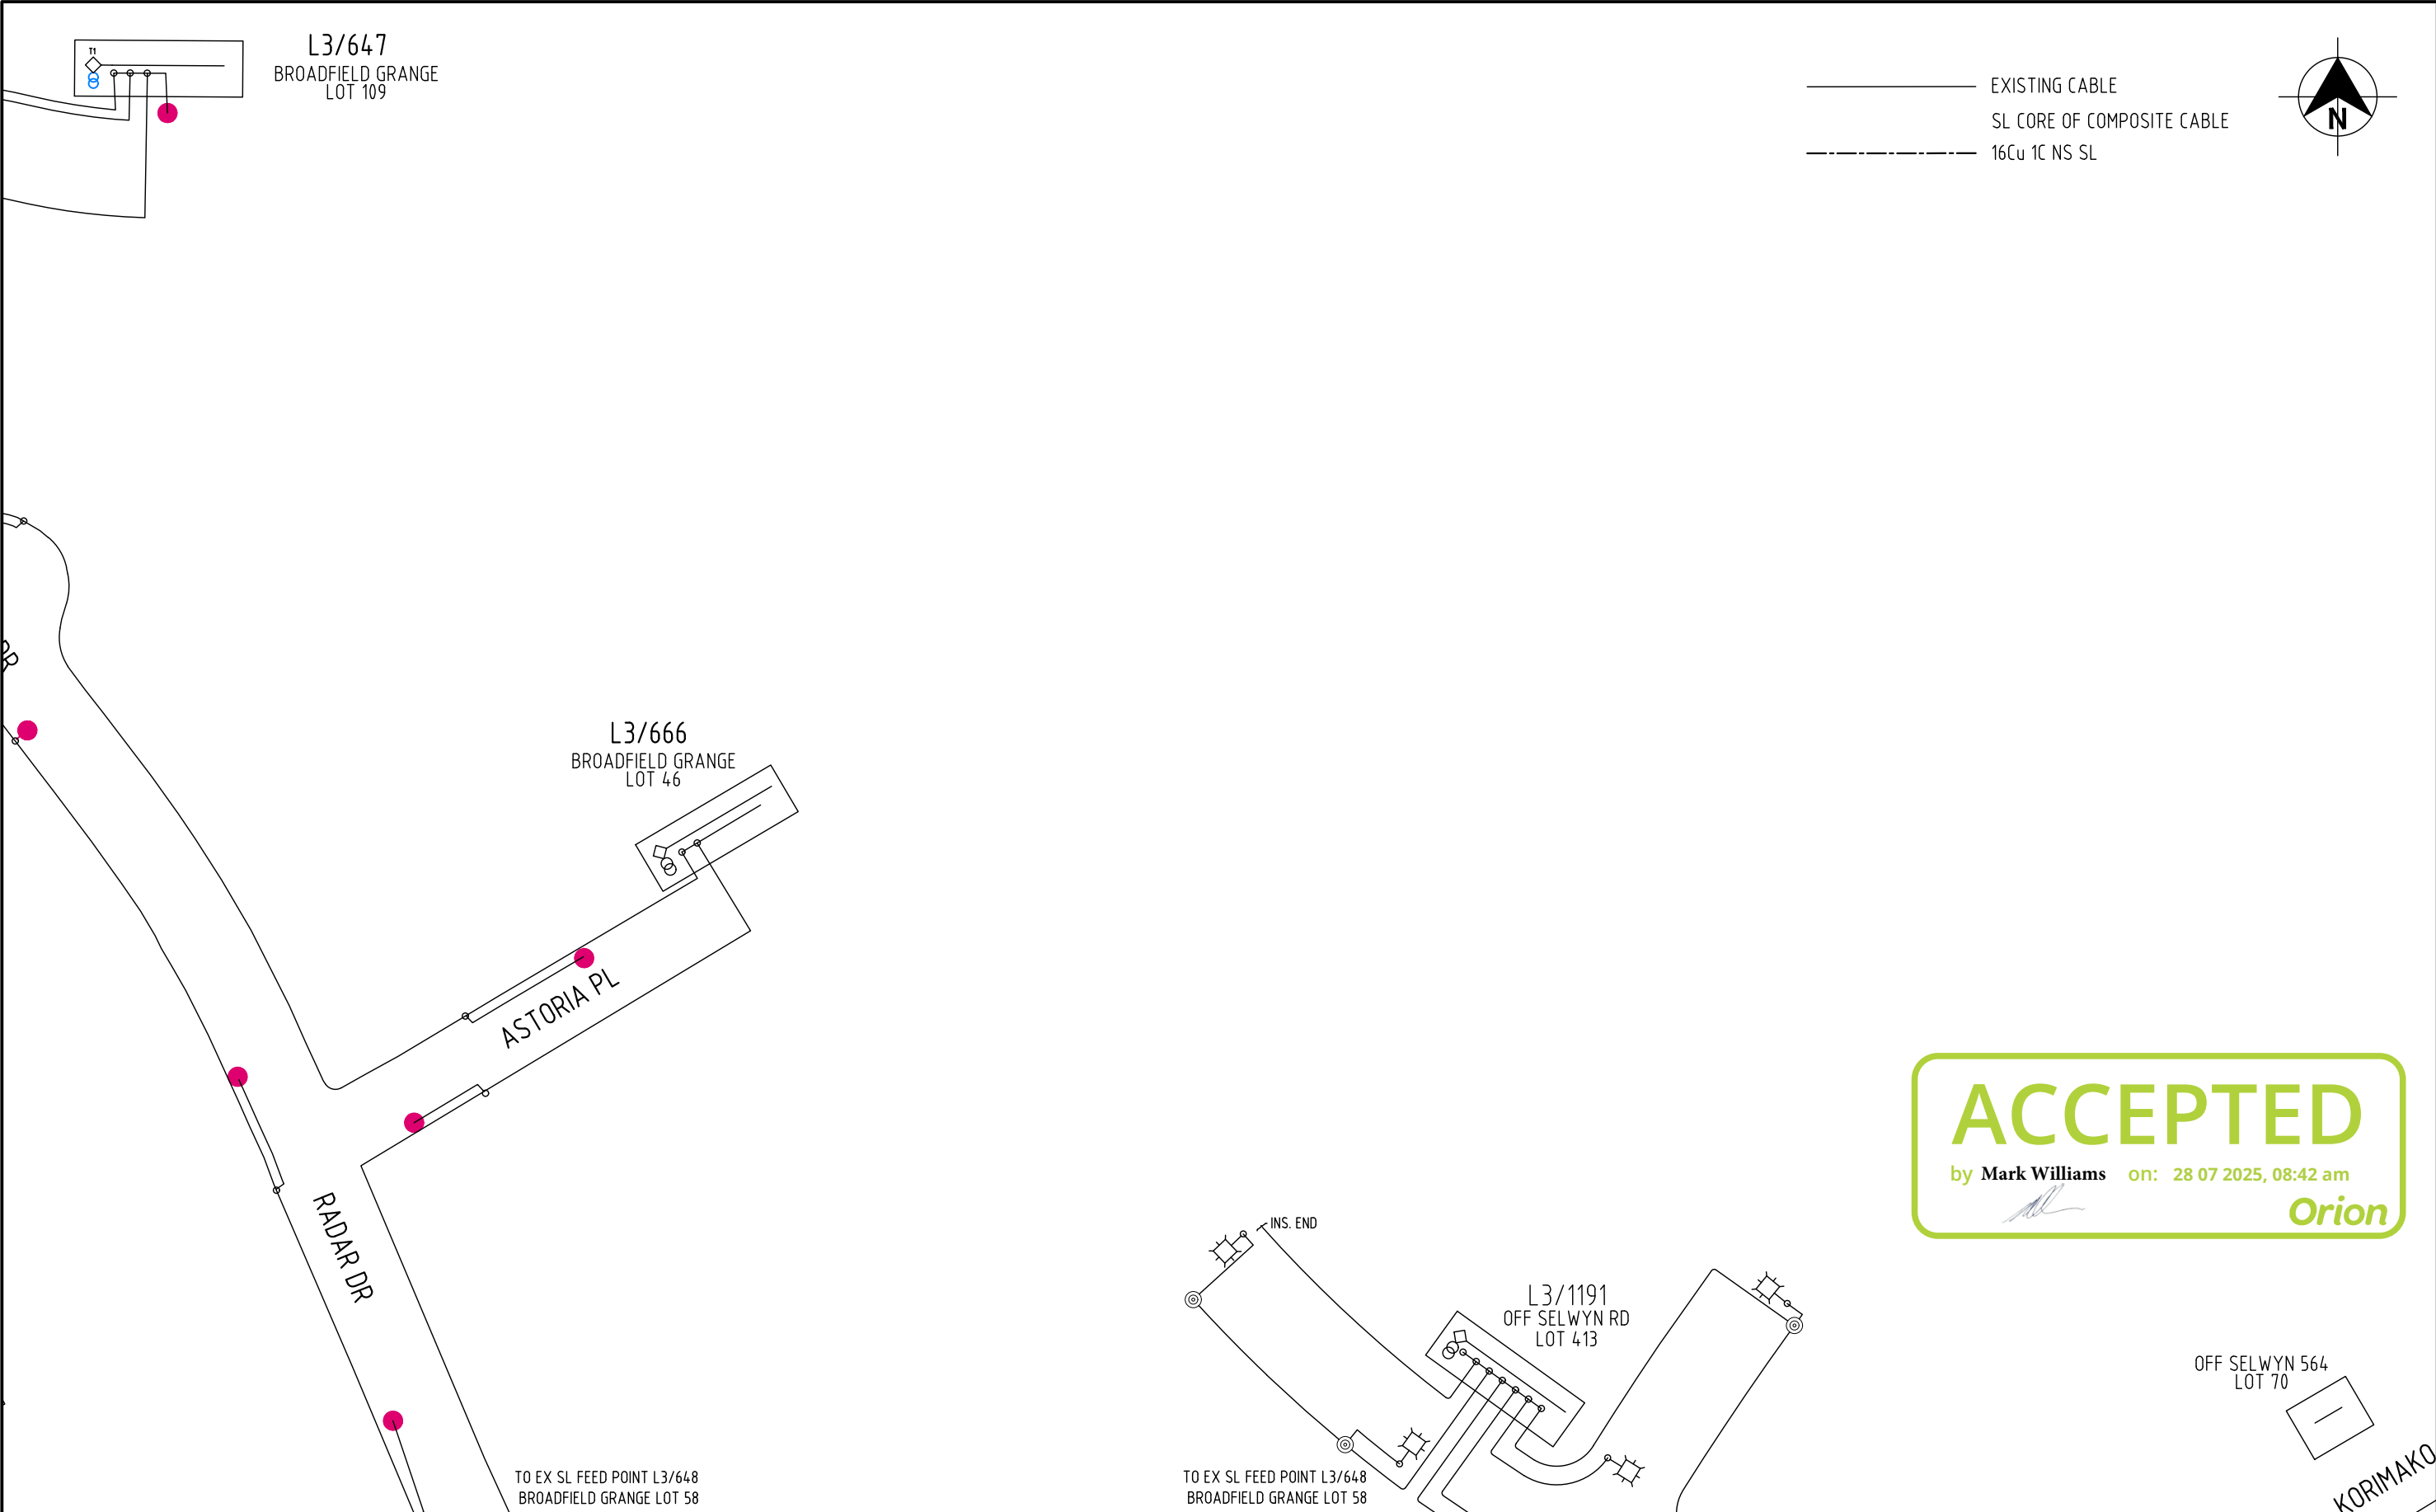


ACCEPTED
by Mark Williams on: 28 07 2025, 08:42 am
Orion

ISSUE	DESCRIPTION	DATE	DESIGN	DRAWN	CHECKD	TASK	NAME	SIGNATURE	DATED	BROADFIELD GRANGE STAGE 12			 ALL WAYS CONNECTING		
A	ORIGINAL ISSUE	02/07/25	A.M.	A.M.	N.J.	DESIGNED	A. MECHEN		30/05/25	38 LOT RESIDENTIAL SUBDIVISION SL SCHEMATICS - EXISTING					
						DRAWN	A. MECHEN		30/05/25						
						CHECKED	N. JARRETT		02/07/25						
						APPROVED									
						ORN1019050	 CONNETICS LIMITED. ALL RIGHTS RESERVED UNAUTHORISED USE PROHIBITED		A				SCALE(SIZE)	DRAWING NO.	SHEET
													NTS (A3)	106908	S12-SL-1

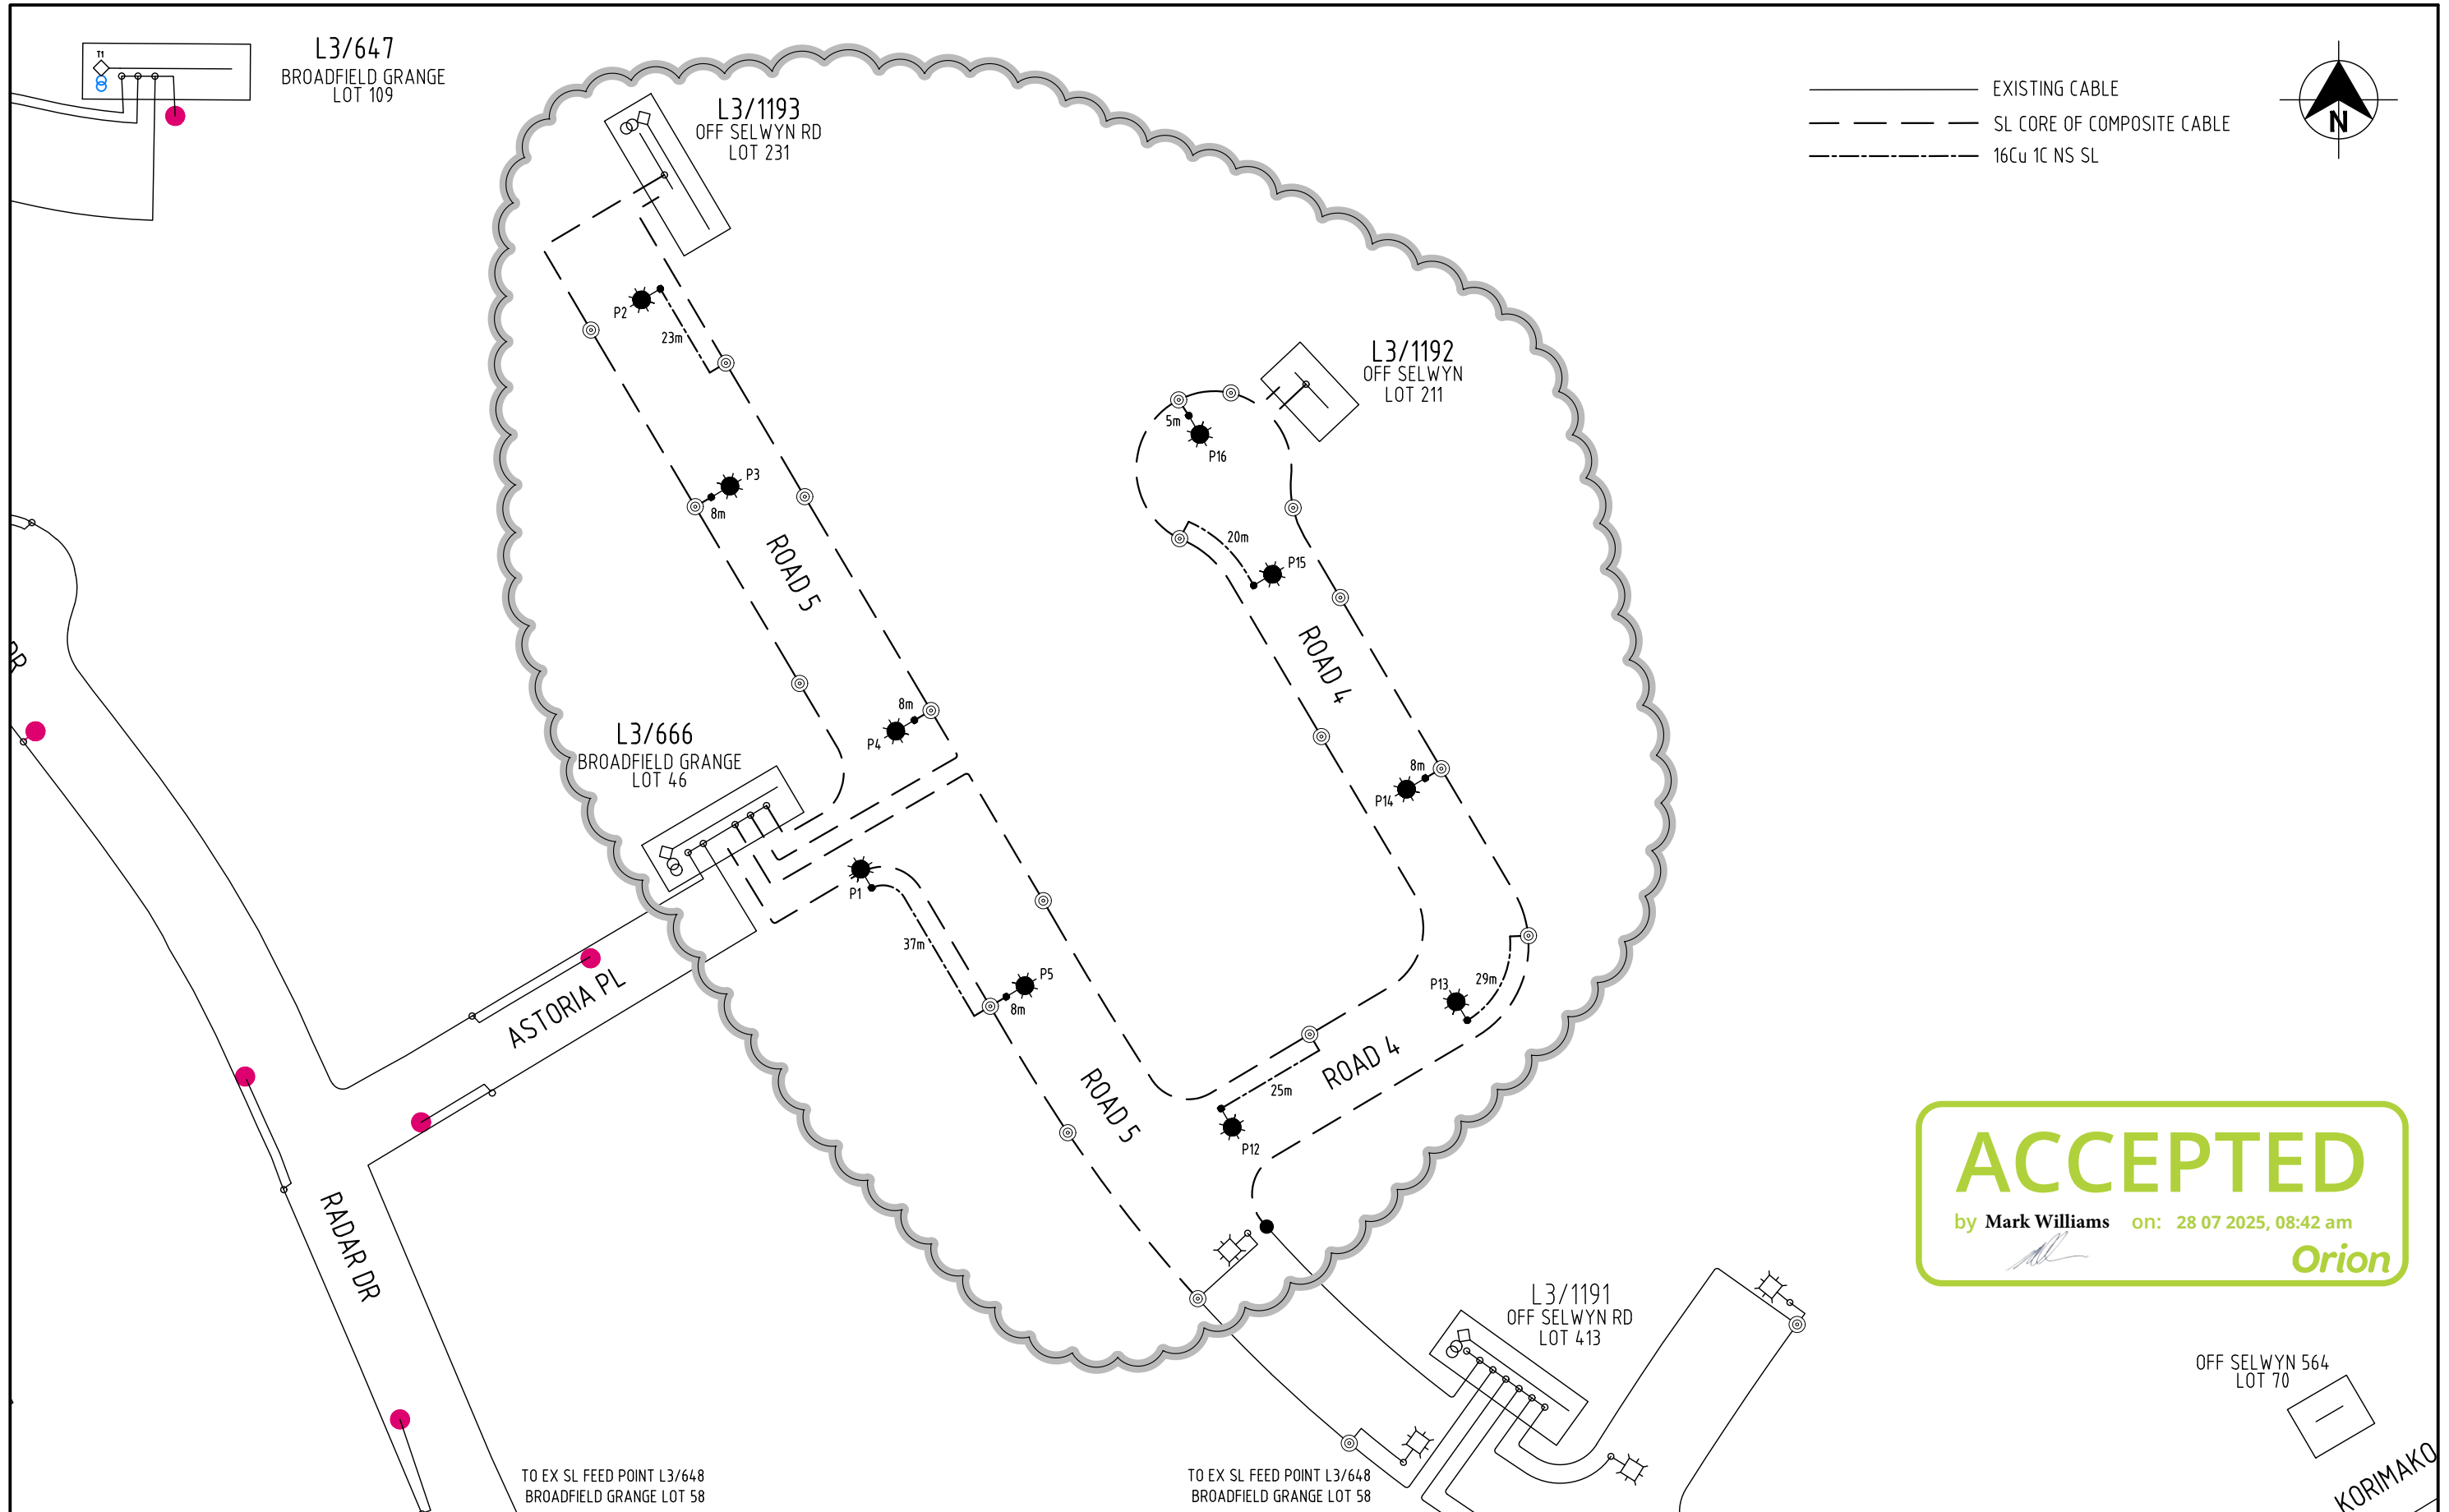

ISSUE	DESCRIPTION	DATE	DESIGN	DRAWN	CHECKD	TASK	NAME	SIGNATURE	DATED	BROADFIELD GRANGE STAGE 12			 connetics ALL WAYS CONNECTING			
A	ORIGINAL ISSUE	02/07/25	A.M.	A.M.	N.J.	DESIGNED	A. MECHEN		30/05/25					SCALE(SIZE)		
						DRAWN	A. MECHEN		30/05/25	38 LOT RESIDENTIAL SUBDIVISION SL SCHEMATICS - PROPOSED				NTS (A3)	106908	S12-SL-2
						CHECKED	N. JARRETT		02/07/25							
						APPROVED										
						ORN1019050	 CONNETICS LIMITED. ALL RIGHTS RESERVED UNAUTHORISED USE PROHIBITED		A							

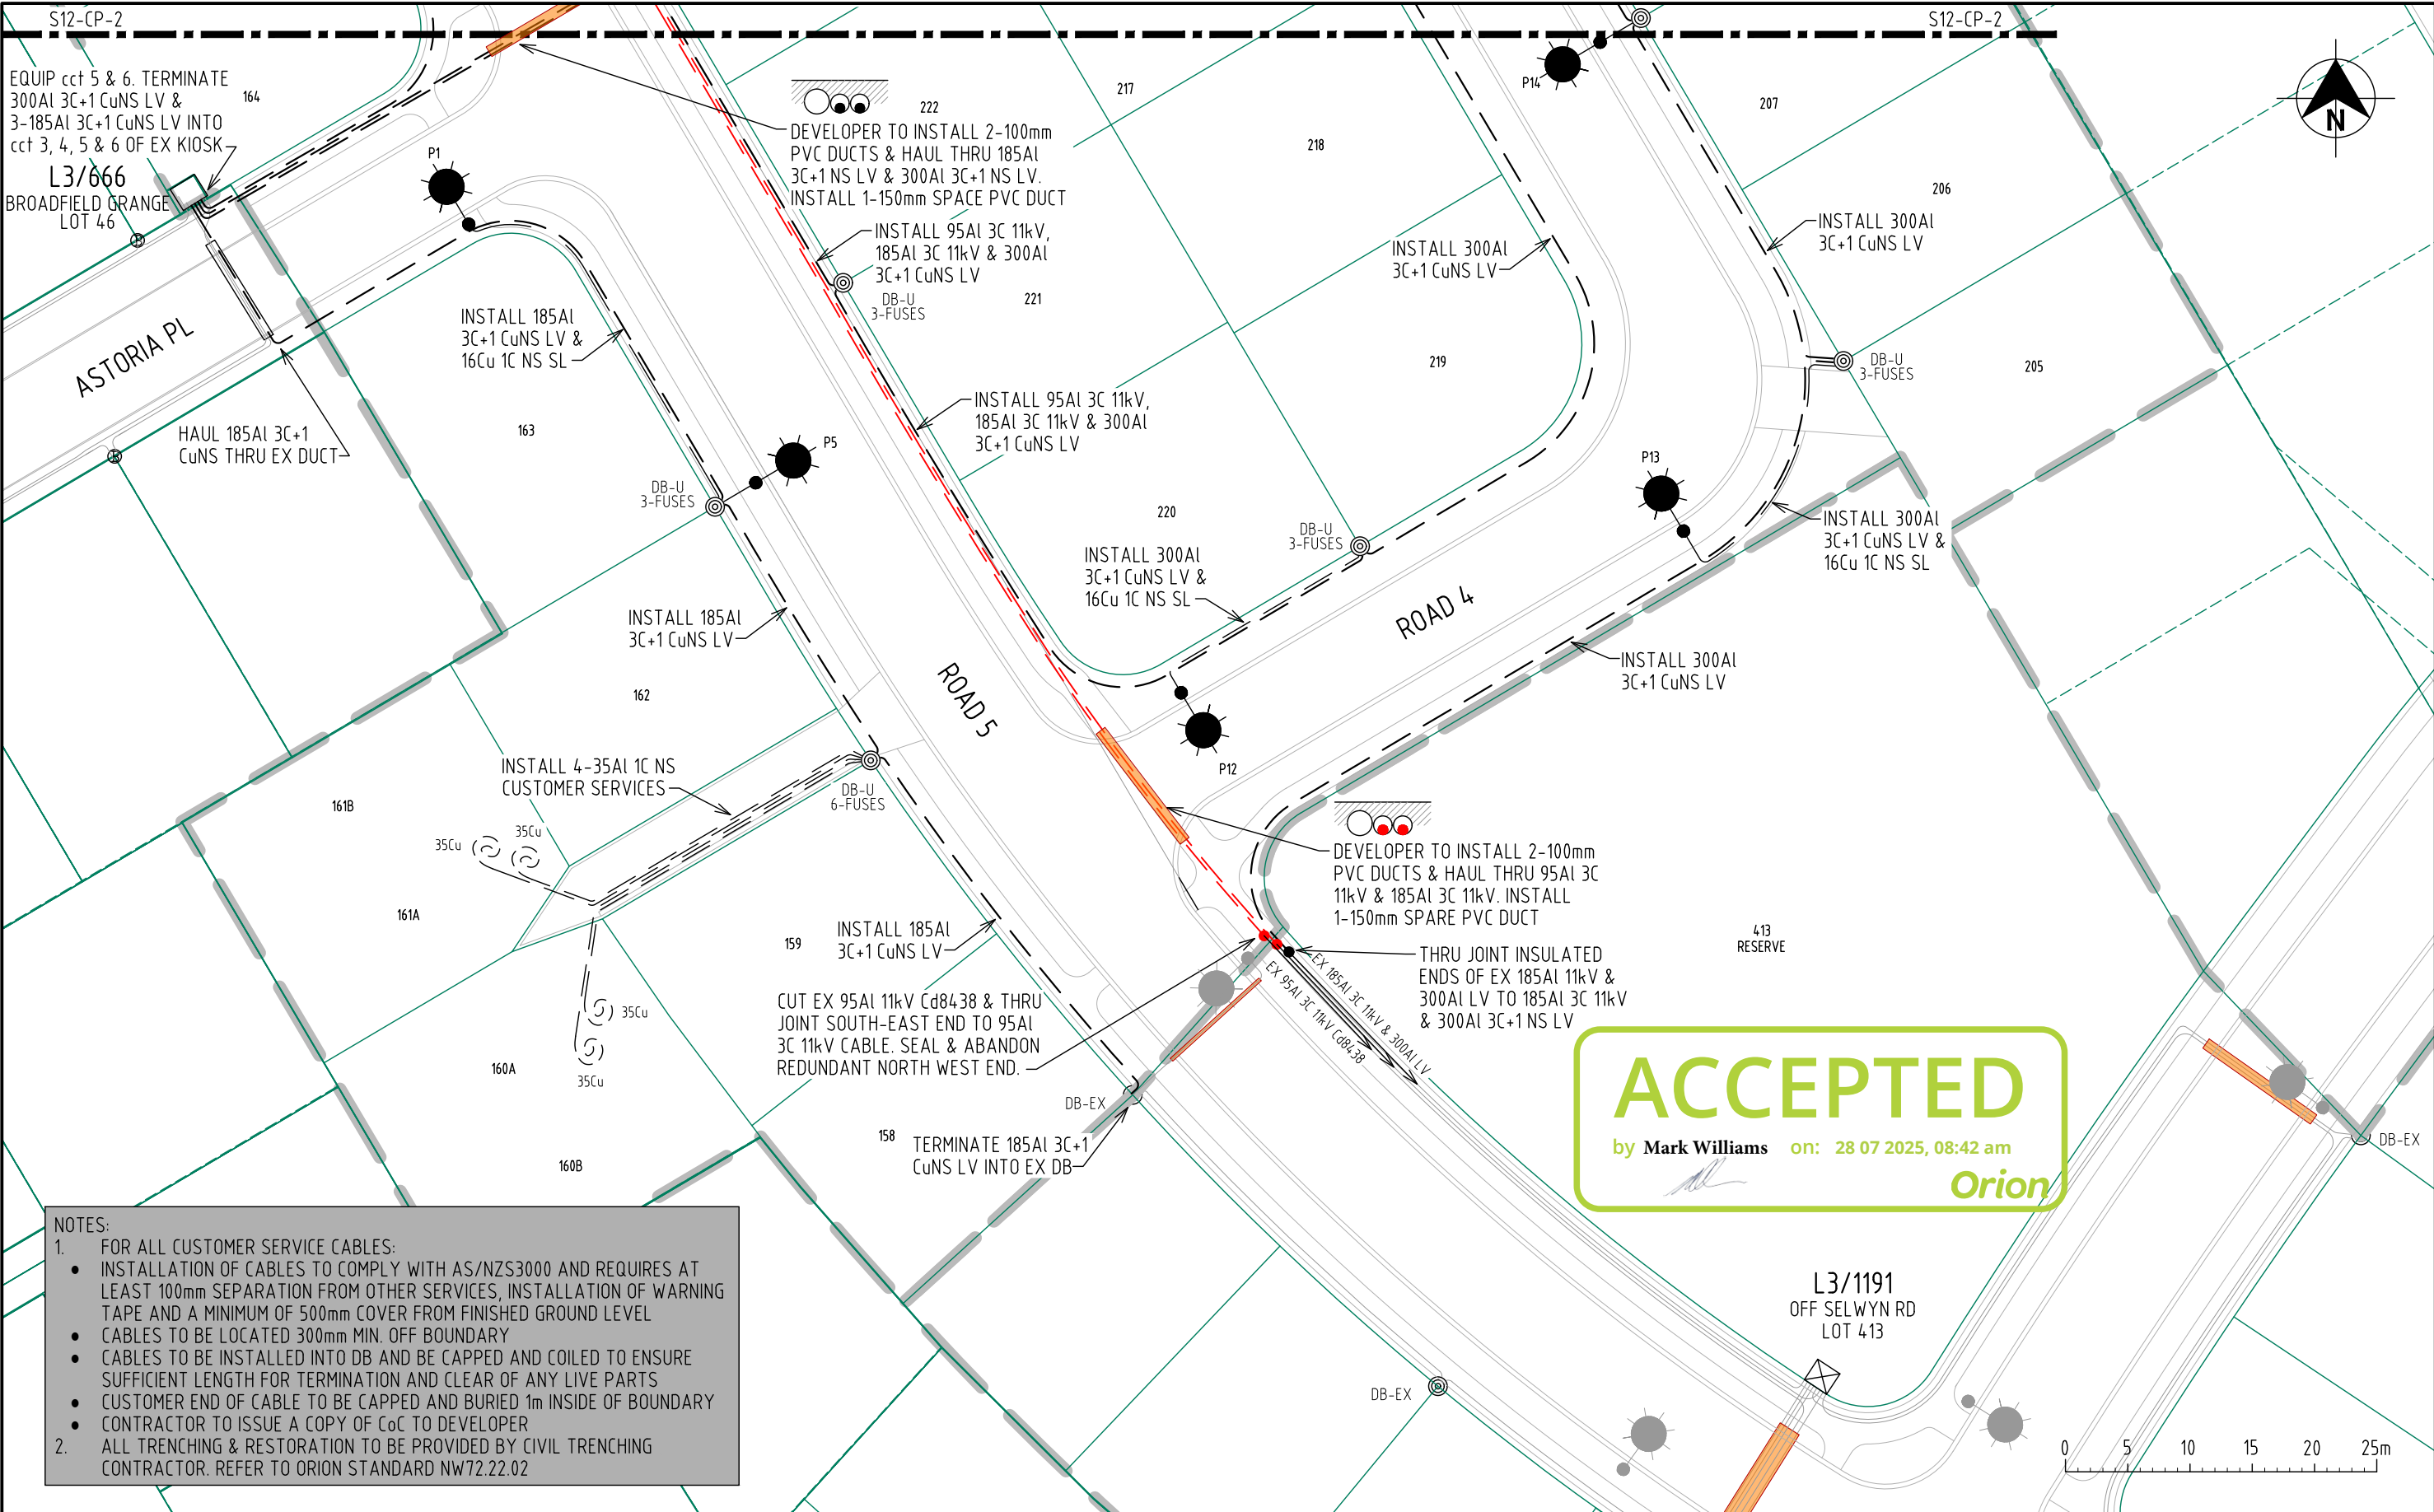

NOTES:

1. FOR ALL CUSTOMER SERVICE CABLES:

- INSTALLATION OF CABLES TO COMPLY WITH AS/NZS3000 AND REQUIRES AT LEAST 100mm SEPARATION FROM OTHER SERVICES, INSTALLATION OF WARNING TAPE AND A MINIMUM OF 500mm COVER FROM FINISHED GROUND LEVEL
- CABLES TO BE LOCATED 300mm MIN. OFF BOUNDARY
- CABLES TO BE INSTALLED INTO DB AND BE CAPPED AND COILED TO ENSURE SUFFICIENT LENGTH FOR TERMINATION AND CLEAR OF ANY LIVE PARTS
- CUSTOMER END OF CABLE TO BE CAPPED AND BURIED 1m INSIDE OF BOUNDARY
- CONTRACTOR TO ISSUE A COPY OF CcC TO DEVELOPER


2. ALL TRENCHING & RESTORATION TO BE PROVIDED BY CIVIL TRENCHING CONTRACTOR. REFER TO ORION STANDARD NW72.22.02

ACCEPTED
by Mark Williams on: 28 07 2025, 08:42 am
Orion

ISSUE	DESCRIPTION	DATE	DESIGN	DRAWN	CHECKD	TASK	NAME	SIGNATURE	DATED
A	ORIGINAL ISSUE	02/07/25	A.M.	A.M.	N.J.	DESIGNED	A. MECHEN		30/05/25
						DRAWN	A. MECHEN		30/05/25
						CHECKED	N. JARRETT		02/07/25
						APPROVED			
						ORN1019050	CONNETICS LIMITED. ALL RIGHTS RESERVED UNAUTHORISED USE PROHIBITED		A

BROADFIELD GRANGE STAGE 12
38 LOT RESIDENTIAL SUBDIVISION
CABLE PLAN

connetics ALL WAYS CONNECTING		
SCALE(SIZE)	DRAWING NO.	SHEET
1:500	106908	S12-CP-1

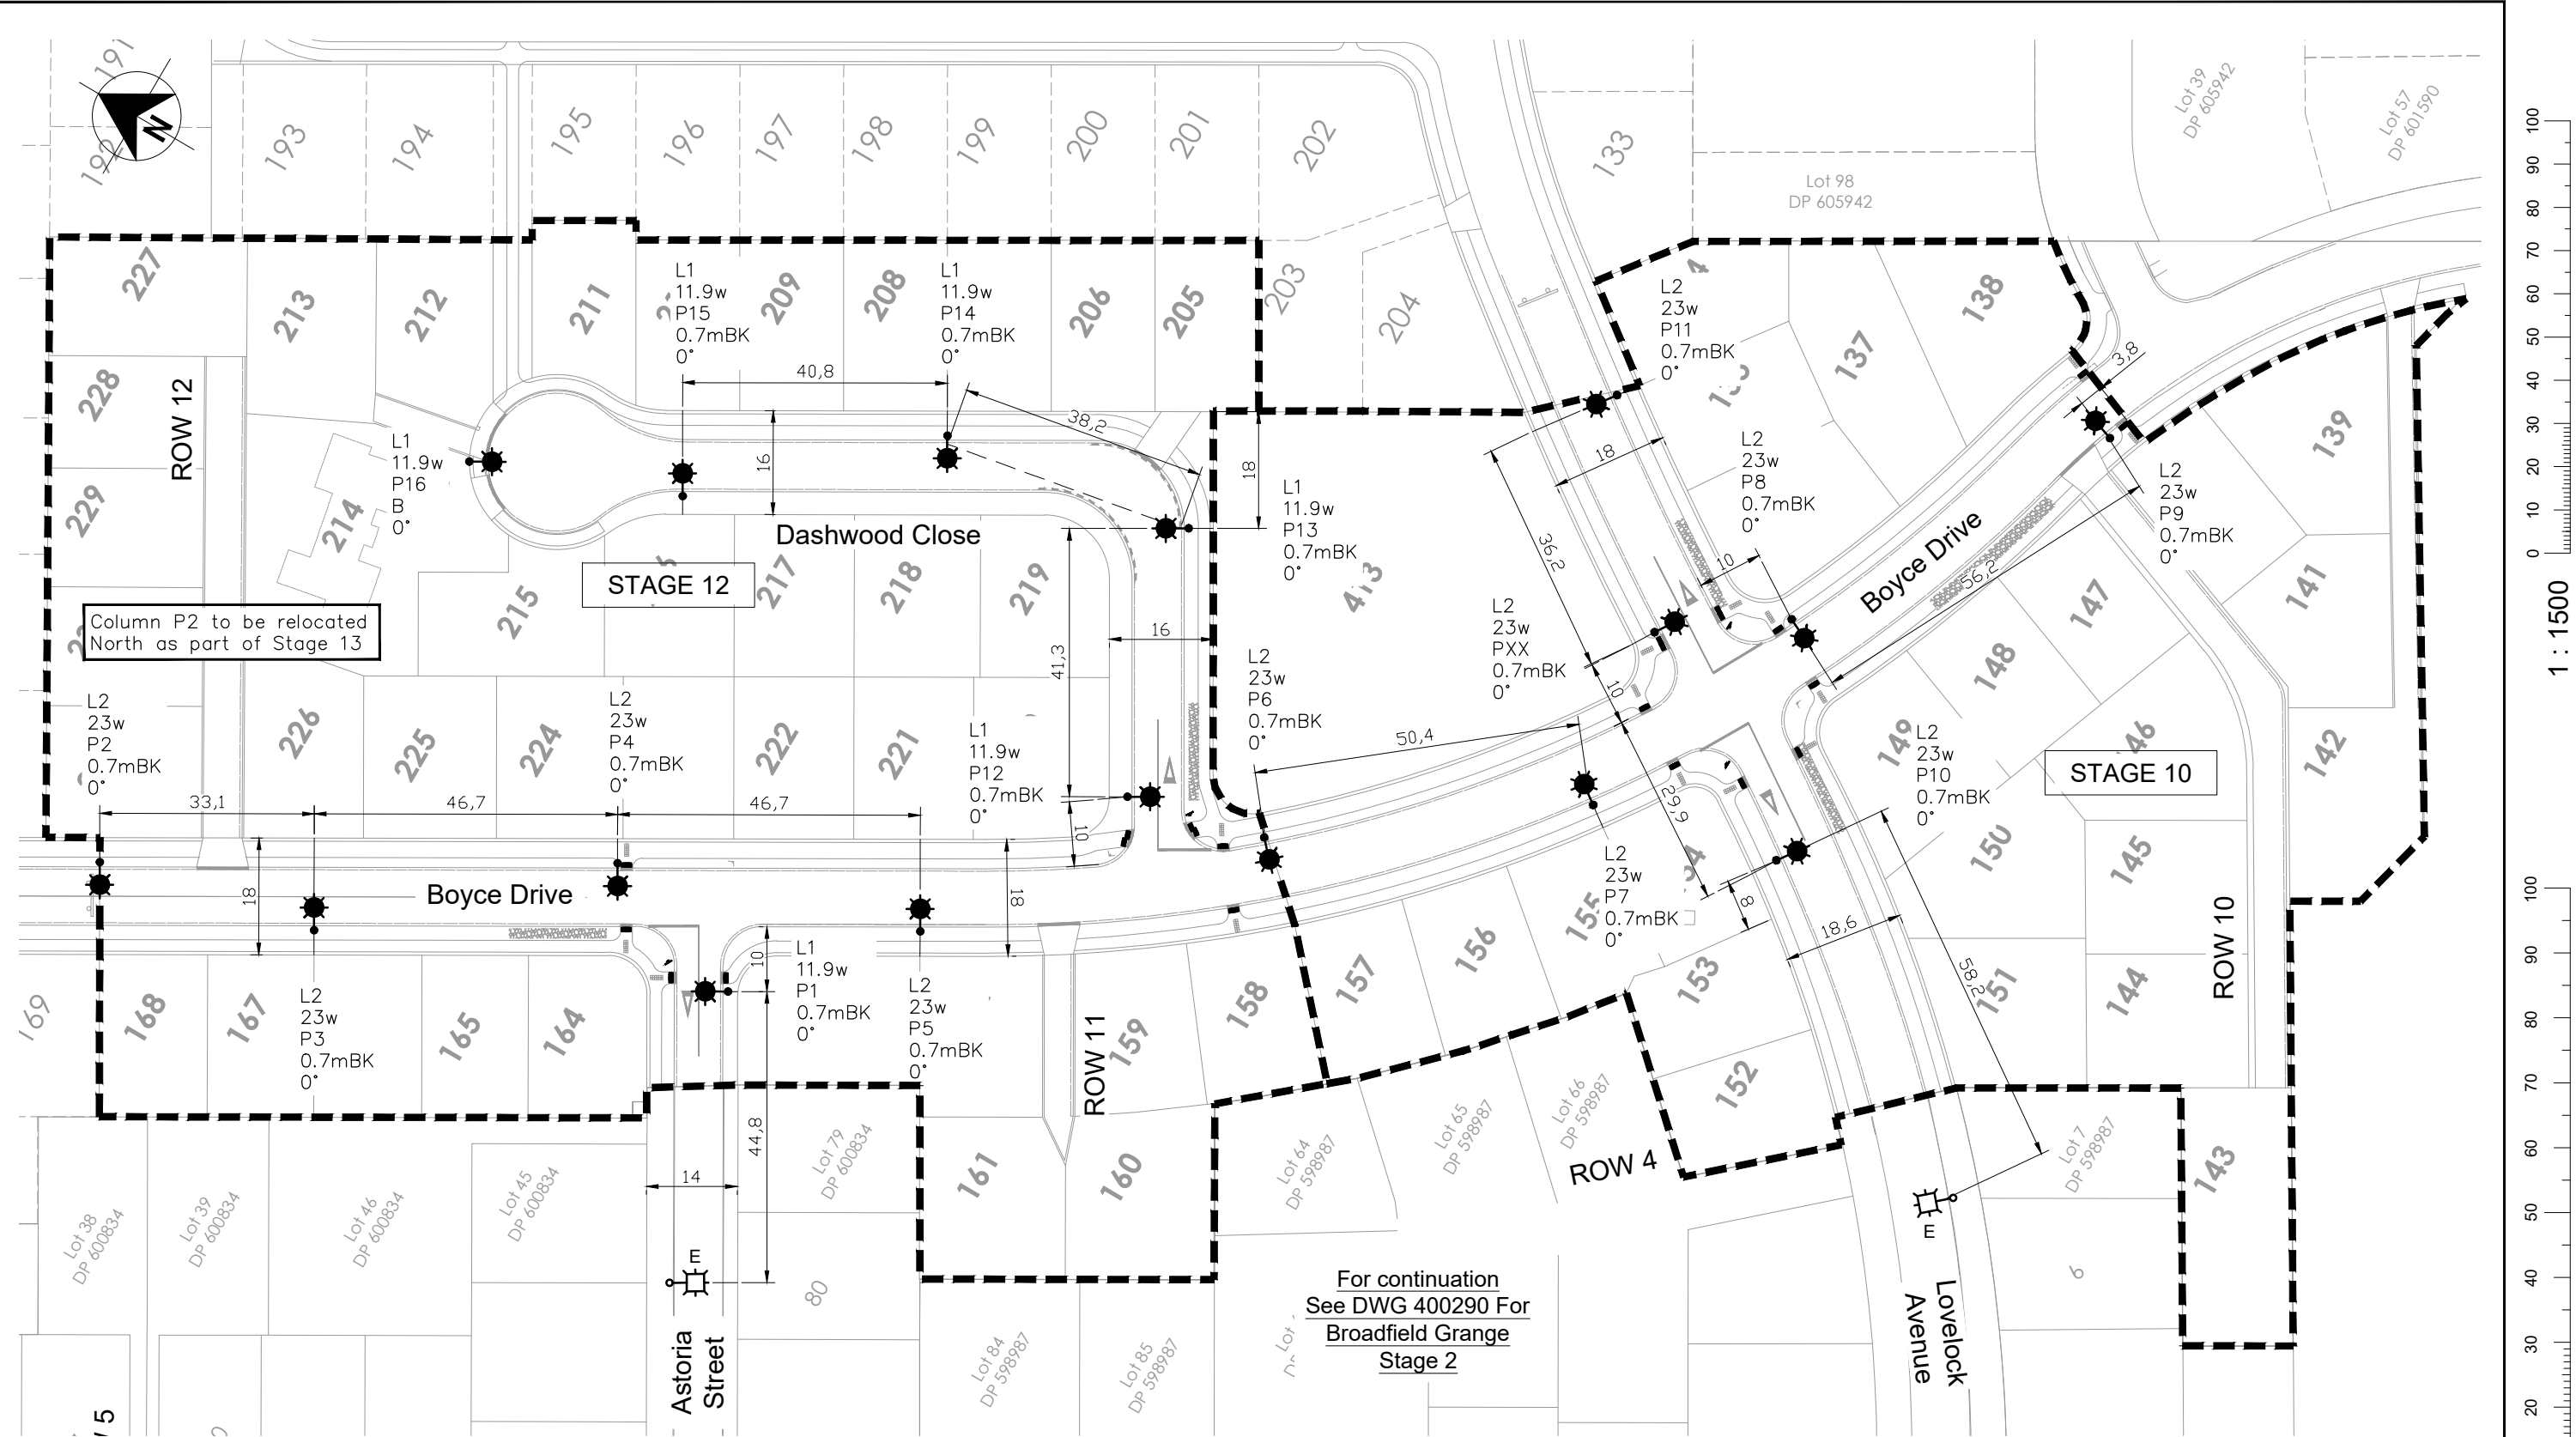

Column P2 to be relocated North as part of Stage 13

STAGE 12

STAGE 10

For continuation
See DWG 400290 For
Broadfield Grange
Stage 2

NOTES:

- 1. Refer to Sheet 1 for Luminaire Schedule and Legend.

ISSUED FOR INFORMATION
Friday, 16 May 2025 10:29:24 am
NOT FOR CONSTRUCTION



WINDSOR URBAN LTD.
ALL RIGHTS RESERVED.
UNAUTHORISED USE PROHIBITED

Rev	Description	Date	Des	Dn	Chk	Apd	Or Acp	Contractor	Designed	R. St-Denis / Conn	May 25	Scale
A	Issued to Client for Comments	16/05/25	RSD	RSD	-	-	-	-	Drawn	R. St-Denis / Conn	May 25	1:1000
									Checked	J. Lim / Conn	-	
									Approved	B. Hayman for SDC	-	
									Connetics	-	-	Revision
												A


STREETLIGHTING LAYOUT

Broadfield Grange Sub-Division
Phase 2 - Stage 10 & 12
East Rolleston




611 Halswell Junction Rd, Hornby, Christchurch, NZ
Phone: (03) 349-7653 Fax: (03) 349-6529 Freephone: (0800) 845-845
Email: info@windsorurban.co.nz


Size	Drawing Number	Sheet
A3	400386	2 / 2

 

EXISTING

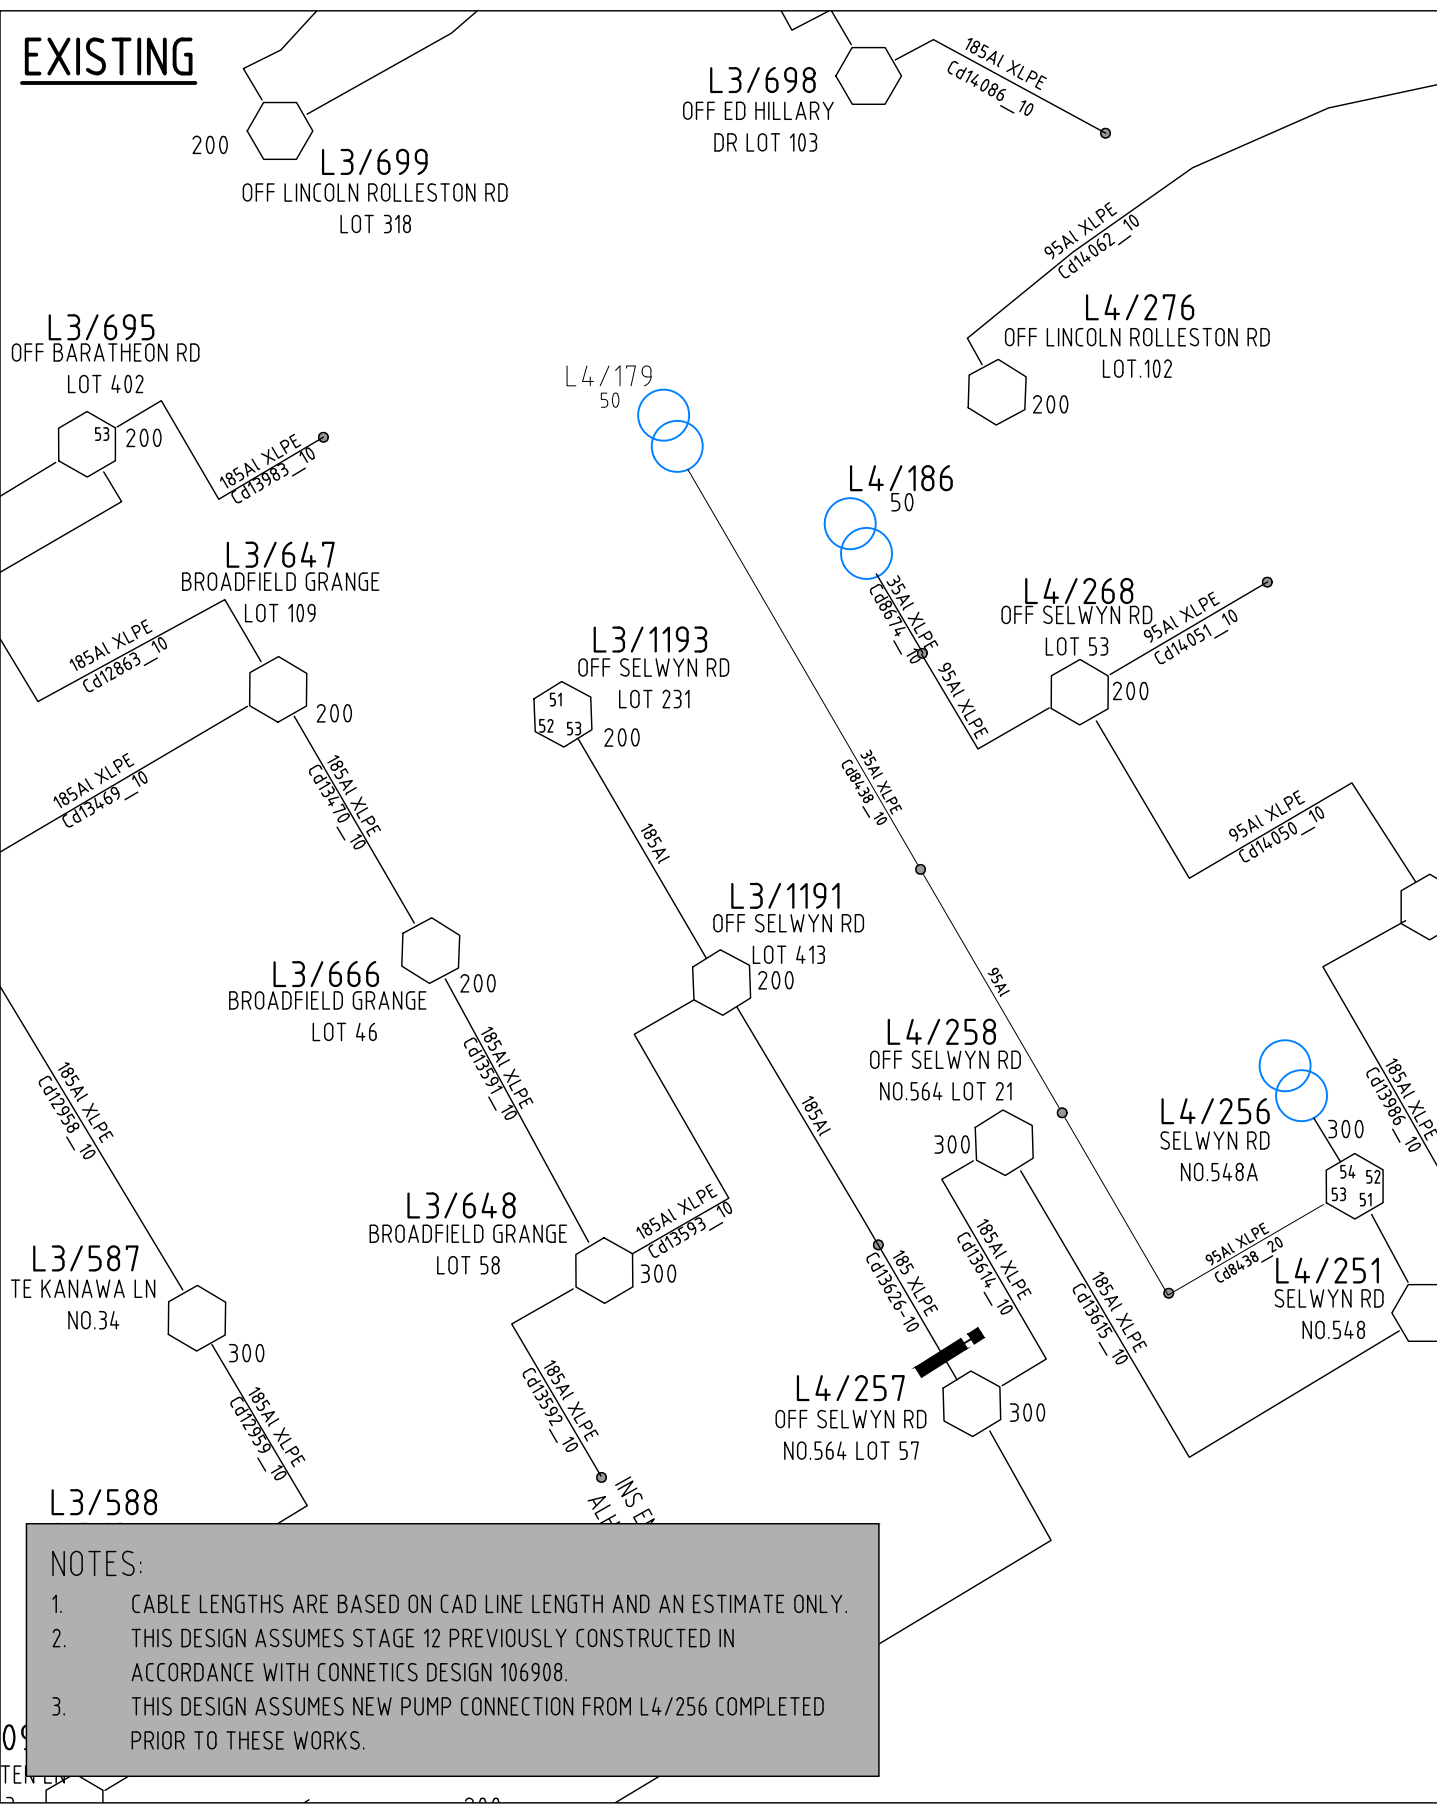


PROPOSED

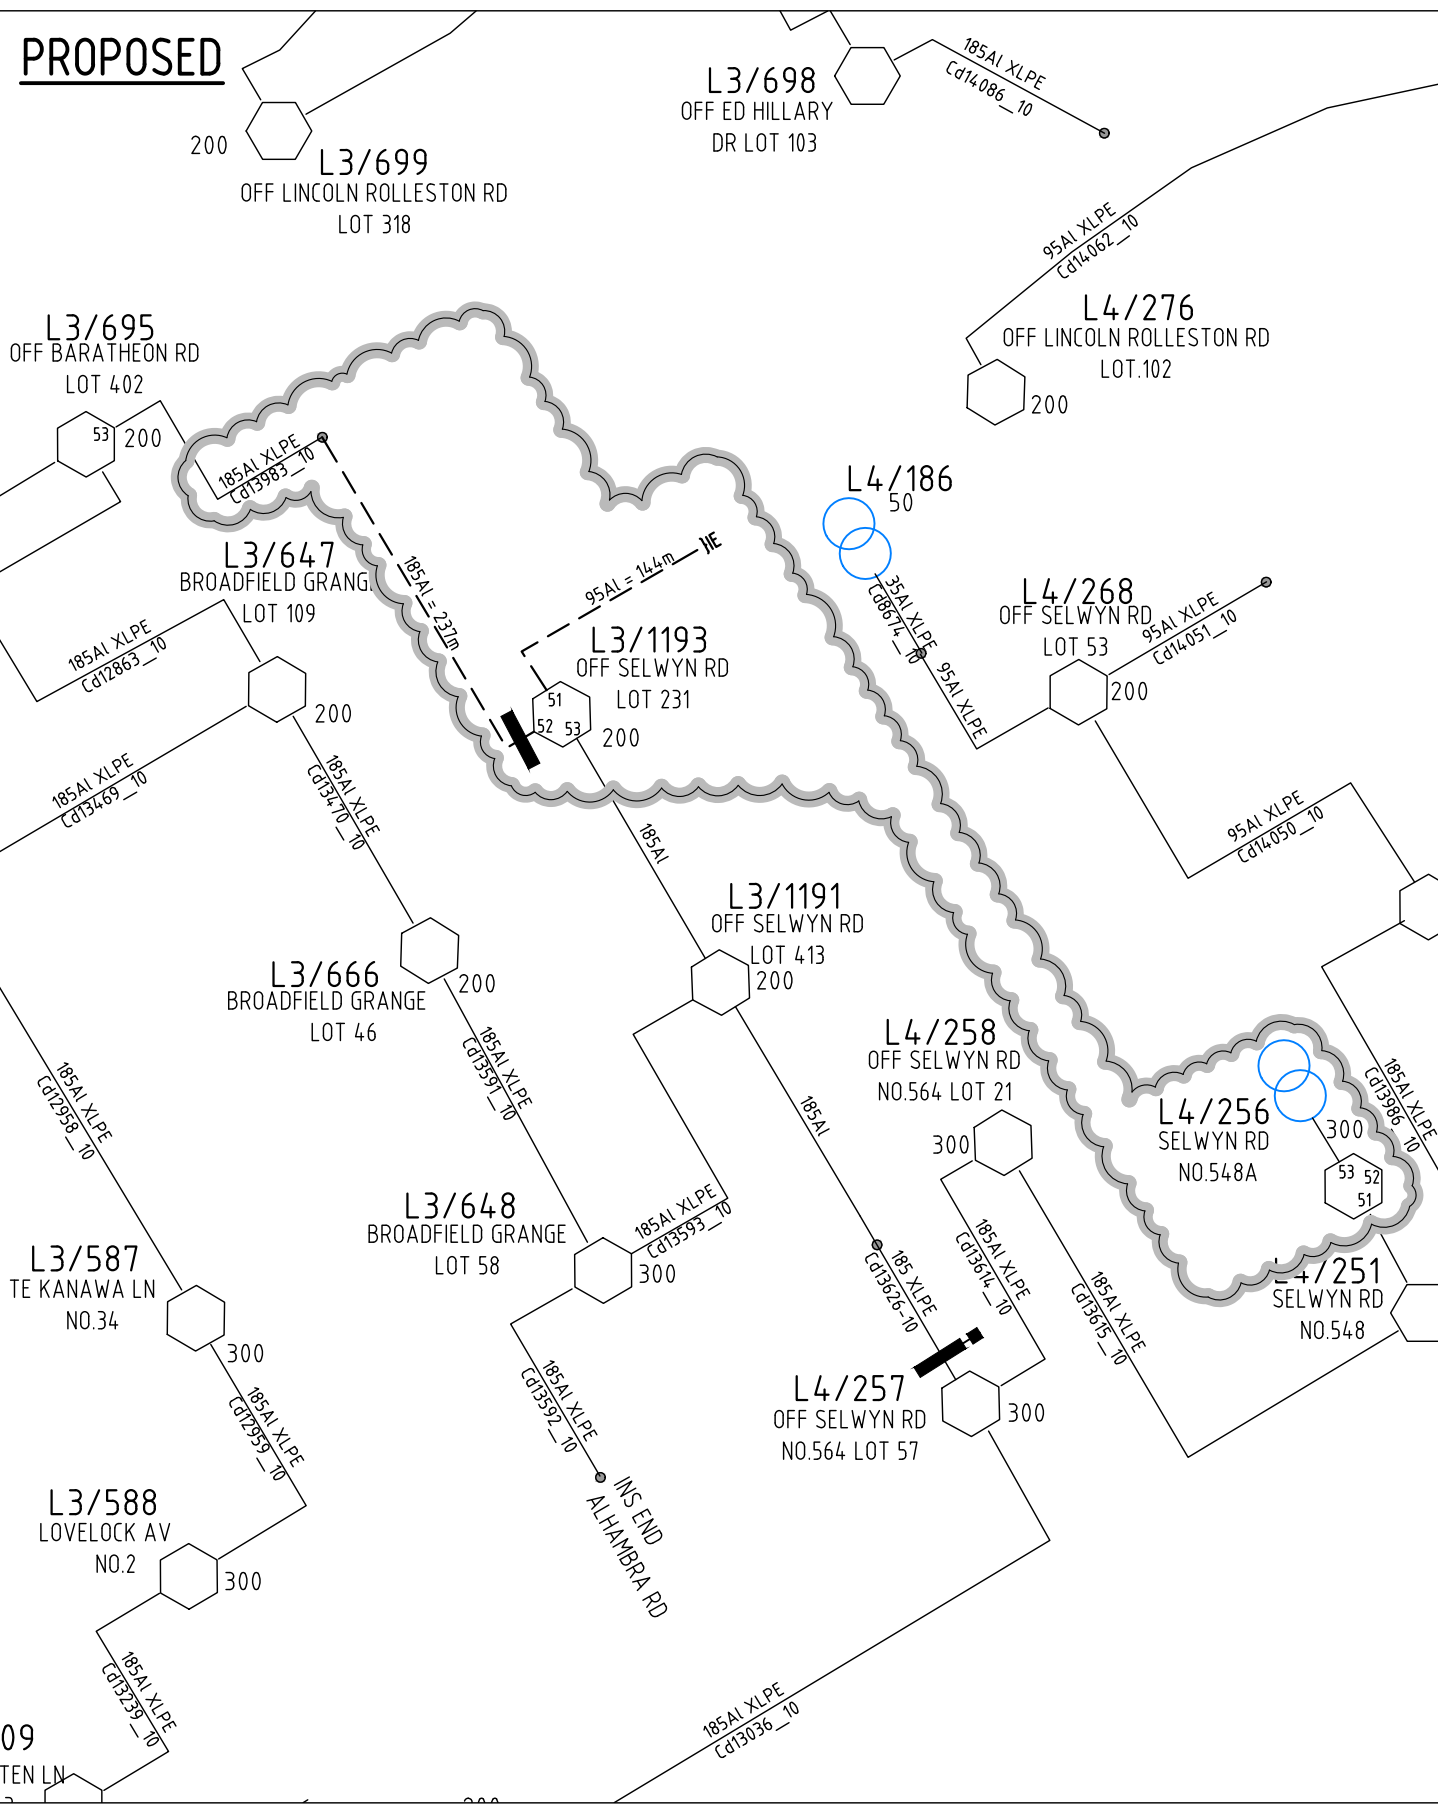

- NOTES:
1. CABLE LENGTHS ARE BASED ON CAD LINE LENGTH AND AN ESTIMATE ONLY.
 2. THIS DESIGN ASSUMES STAGE 12 PREVIOUSLY CONSTRUCTED IN ACCORDANCE WITH CONNETICS DESIGN 106908.
 3. THIS DESIGN ASSUMES NEW PUMP CONNECTION FROM L4/256 COMPLETED PRIOR TO THESE WORKS.


ISSUE	DESCRIPTION	DATE	DESIGN	DRAWN	CHECKD	TASK	NAME	SIGNATURE	DATED	BROADFIELD GRANGE STAGE 13		
A	ISSUED FOR CONSTRUCTION	14/10/25	R.P.	R.P.	M.O.	DESIGNED	R. PARKES		14/10/25	HV SCHEMATICS EXISTING & PROPOSED		
						DRAWN	R. PARKES		19/09/25			
						CHECKED	M. OPHUIS		19/09/25			
						APPROVED						
						ORN1021836	CONNETICS LIMITED. ALL RIGHTS RESERVED UNAUTHORISED USE PROHIBITED		A			
										connetics ALLWAYS CONNECTING		
										SCALE(SIZE)	DRAWING NO.	SHEET
										NTS (A3)	107293	HV-01

EXISTING

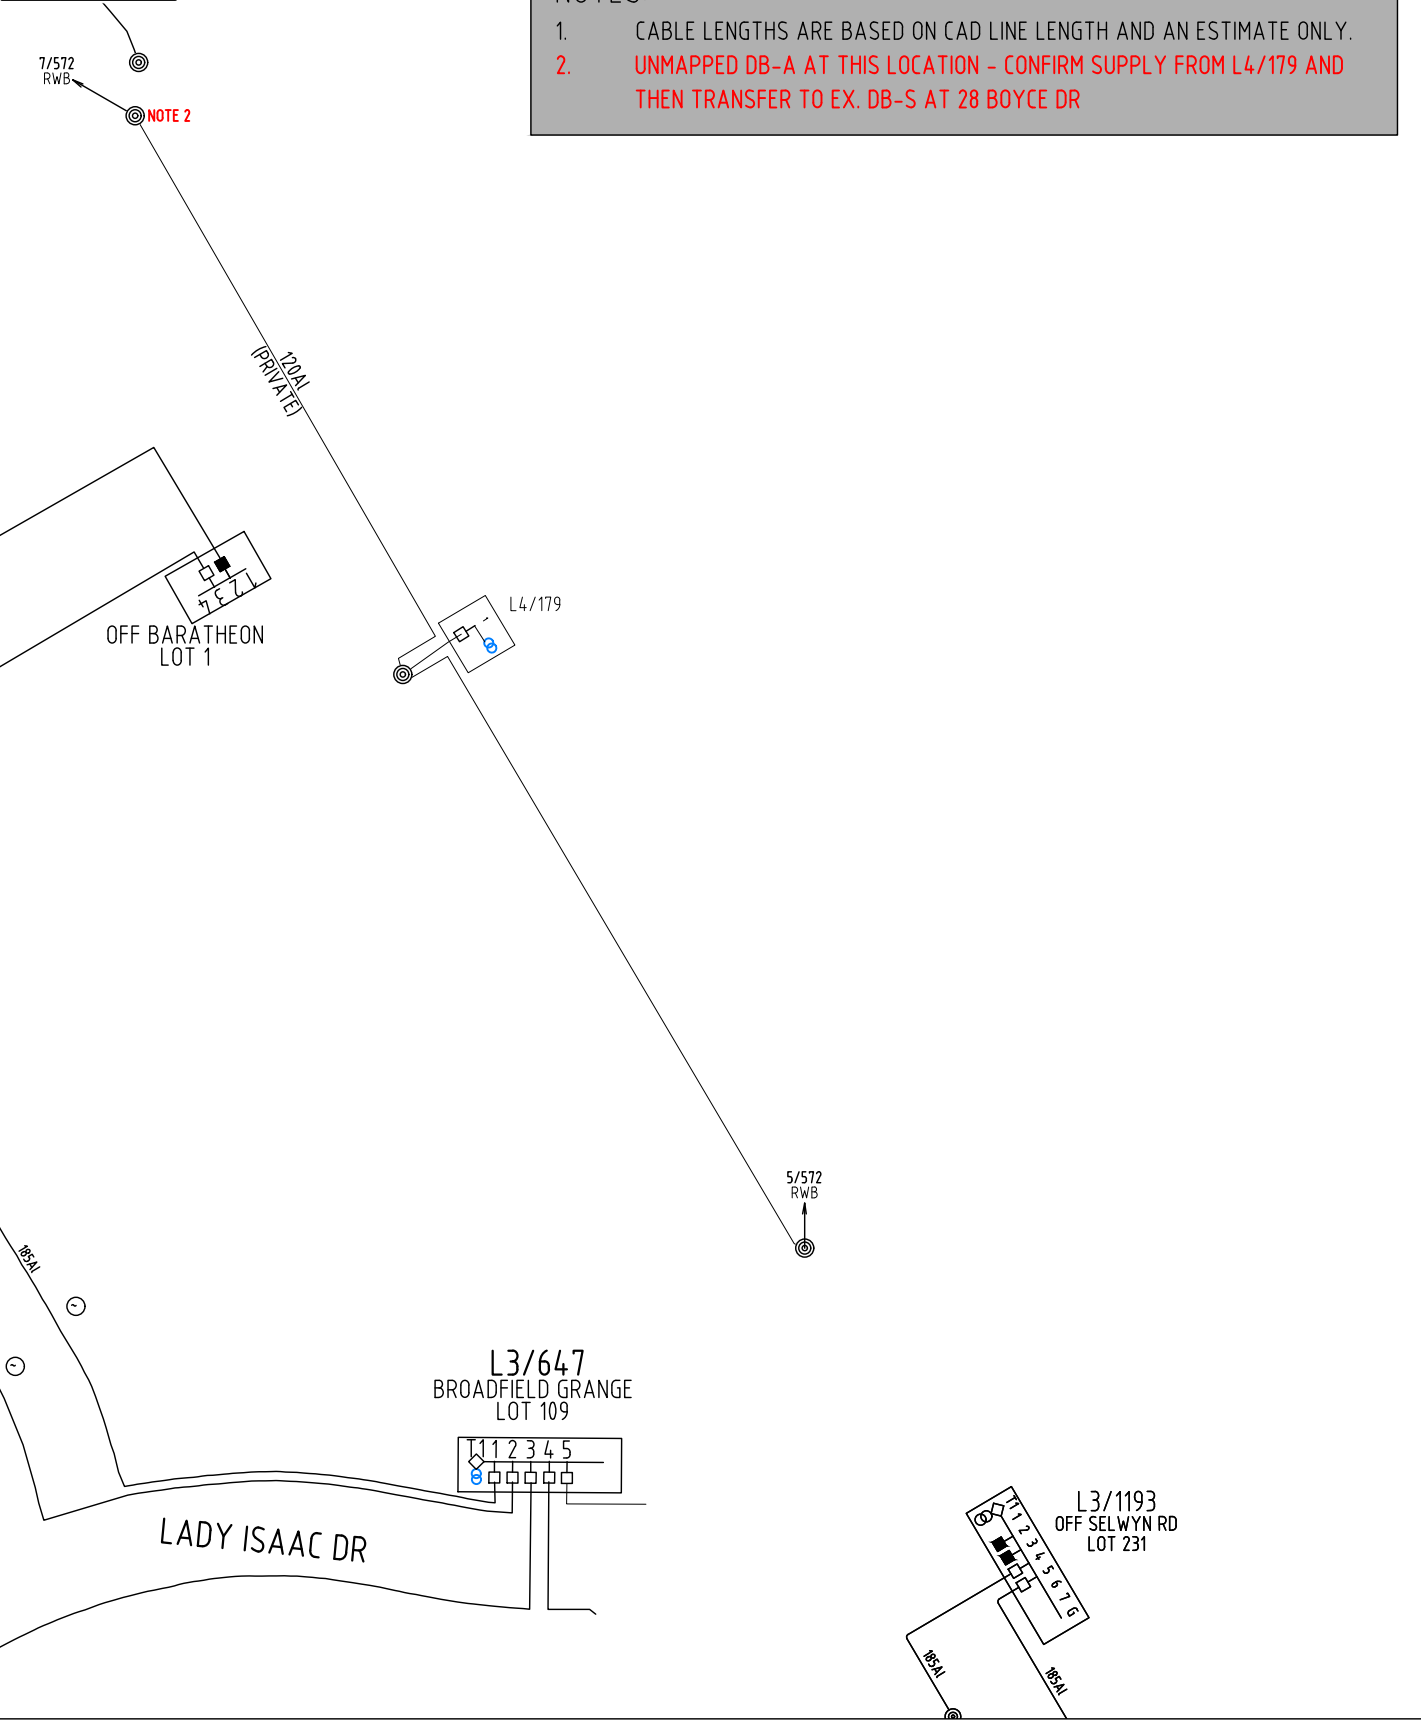

- NOTES:
1. CABLE LENGTHS ARE BASED ON CAD LINE LENGTH AND AN ESTIMATE ONLY.
 2. UNMAPPED DB-A AT THIS LOCATION - CONFIRM SUPPLY FROM L4/179 AND THEN TRANSFER TO EX. DB-S AT 28 BOYCE DR

PROPOSED

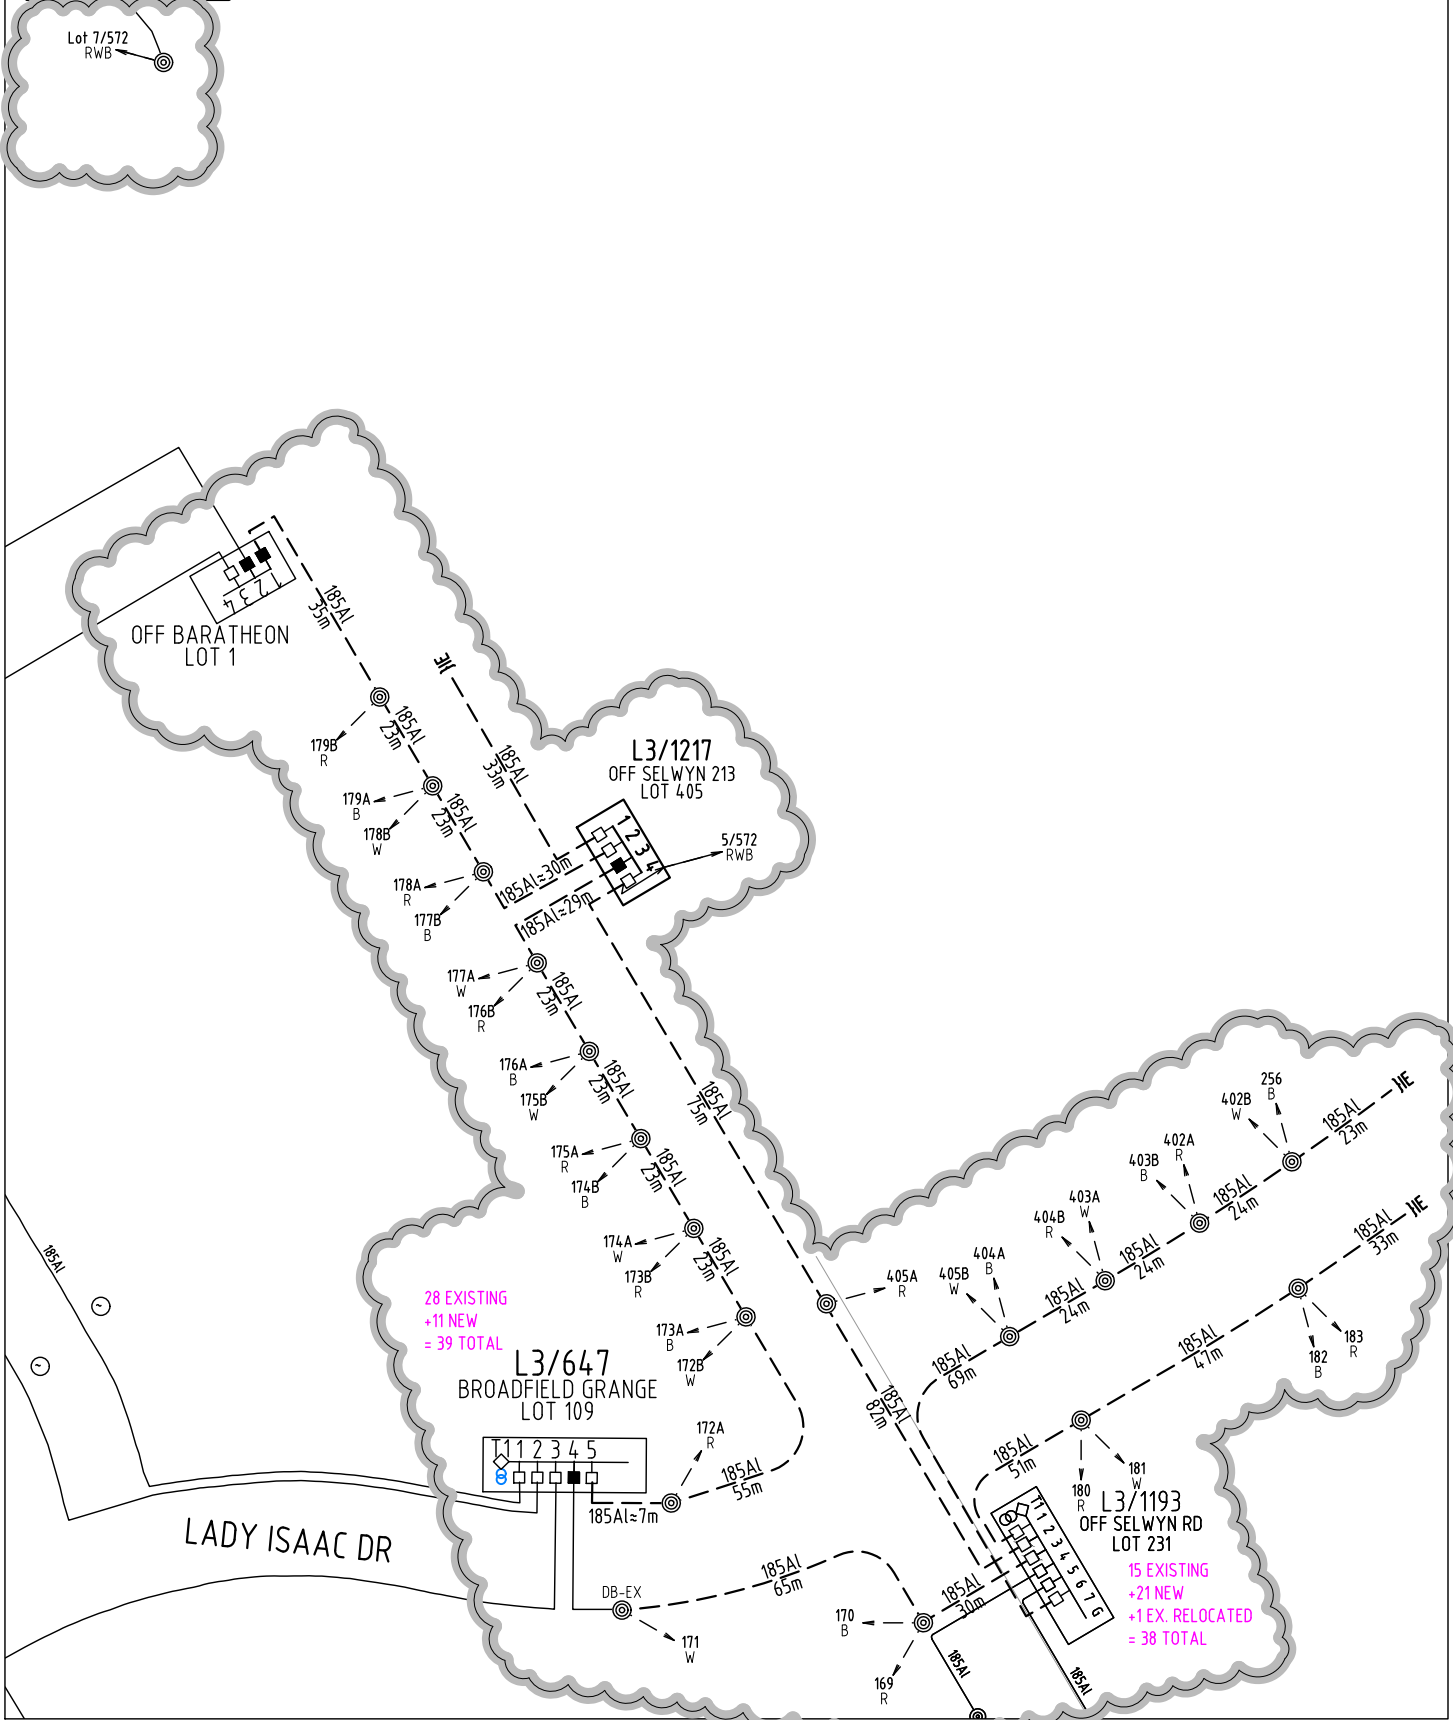

ISSUE	DESCRIPTION	DATE	DESIGN	DRAWN	CHECKD	TASK	NAME	SIGNATURE	DATED
A	ISSUED FOR CONSTRUCTION	14/10/25	R.P.	R.P.	M.O.	DESIGNED	R. PARKES		14/10/25
						DRAWN	R. PARKES		19/09/25
						CHECKED	M. OPHUIS		19/09/25
						APPROVED			
						ORN1021836	CONNETICS LIMITED. ALL RIGHTS RESERVED UNAUTHORISED USE PROHIBITED		A


BROADFIELD GRANGE STAGE 13

LV SCHEMATICS
EXISTING & PROPOSED




SCALE(SIZE)	DRAWING NO.	SHEET
NTS (A3)	107293	LV-01

EXISTING

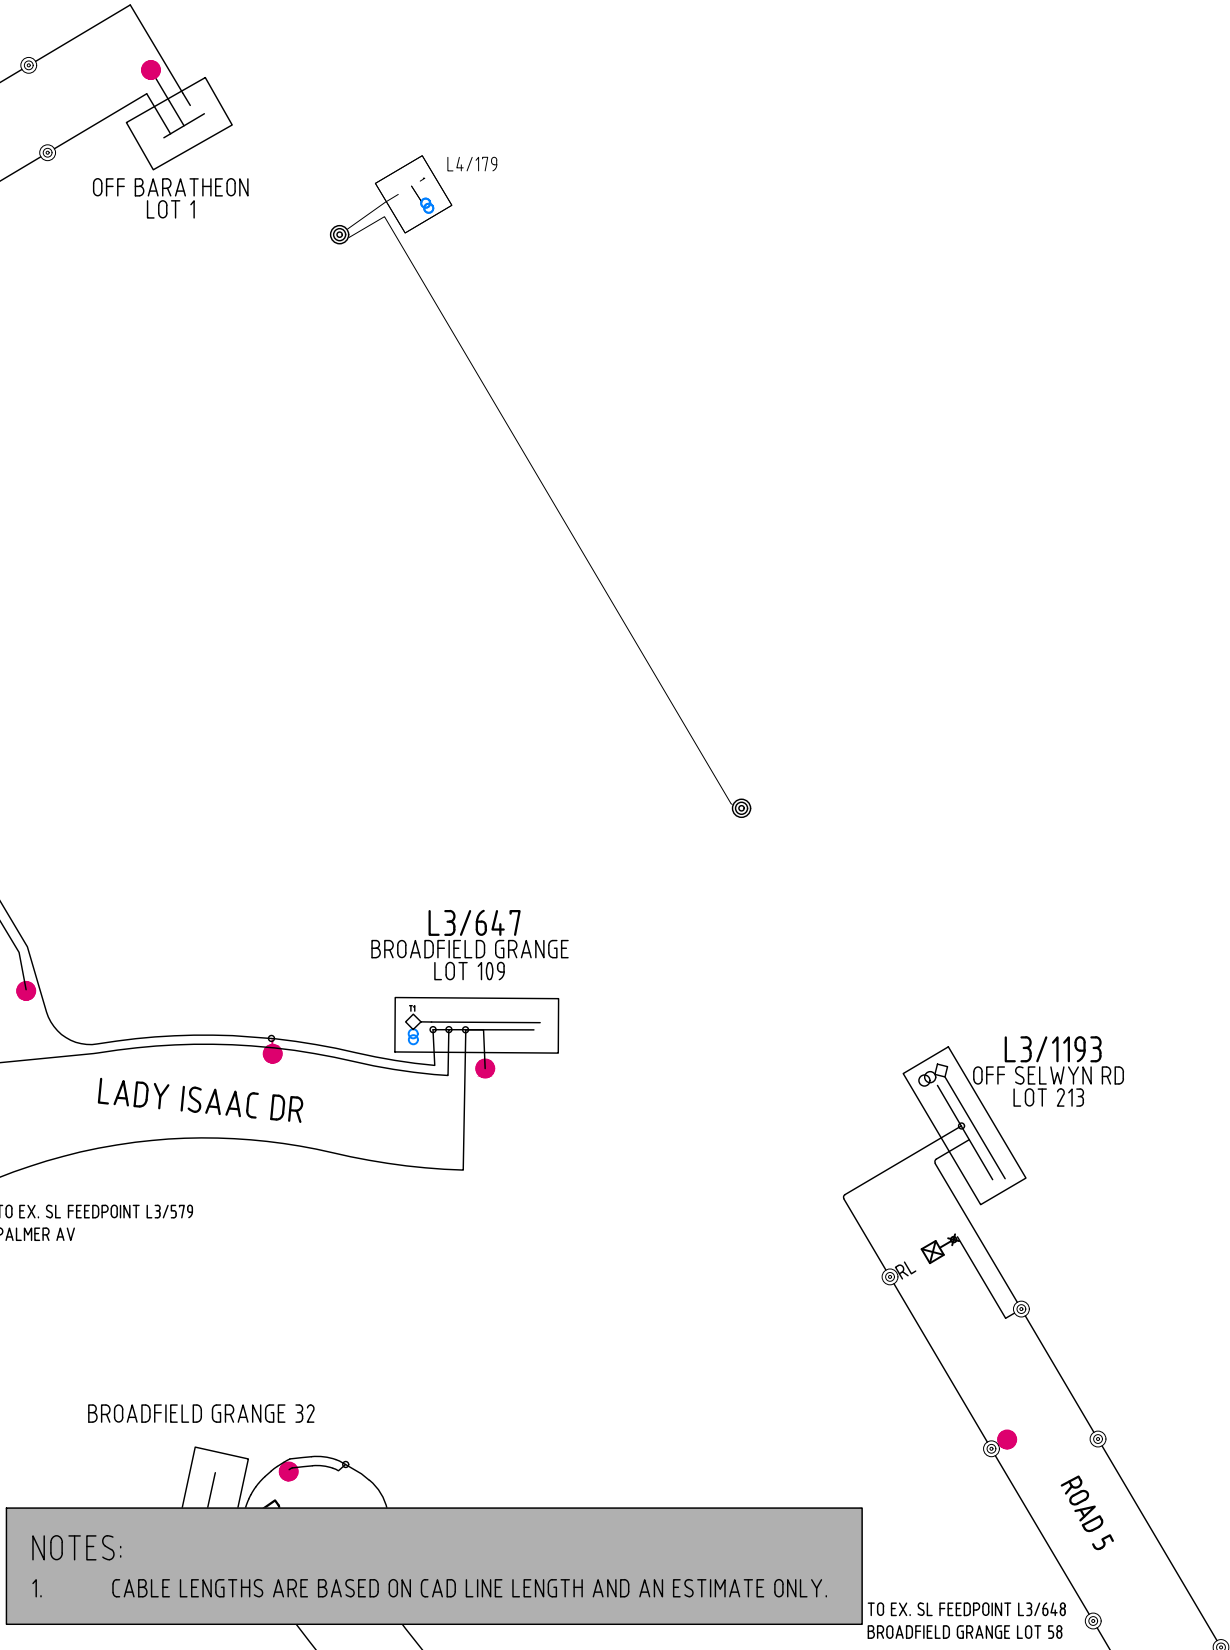

PROPOSED

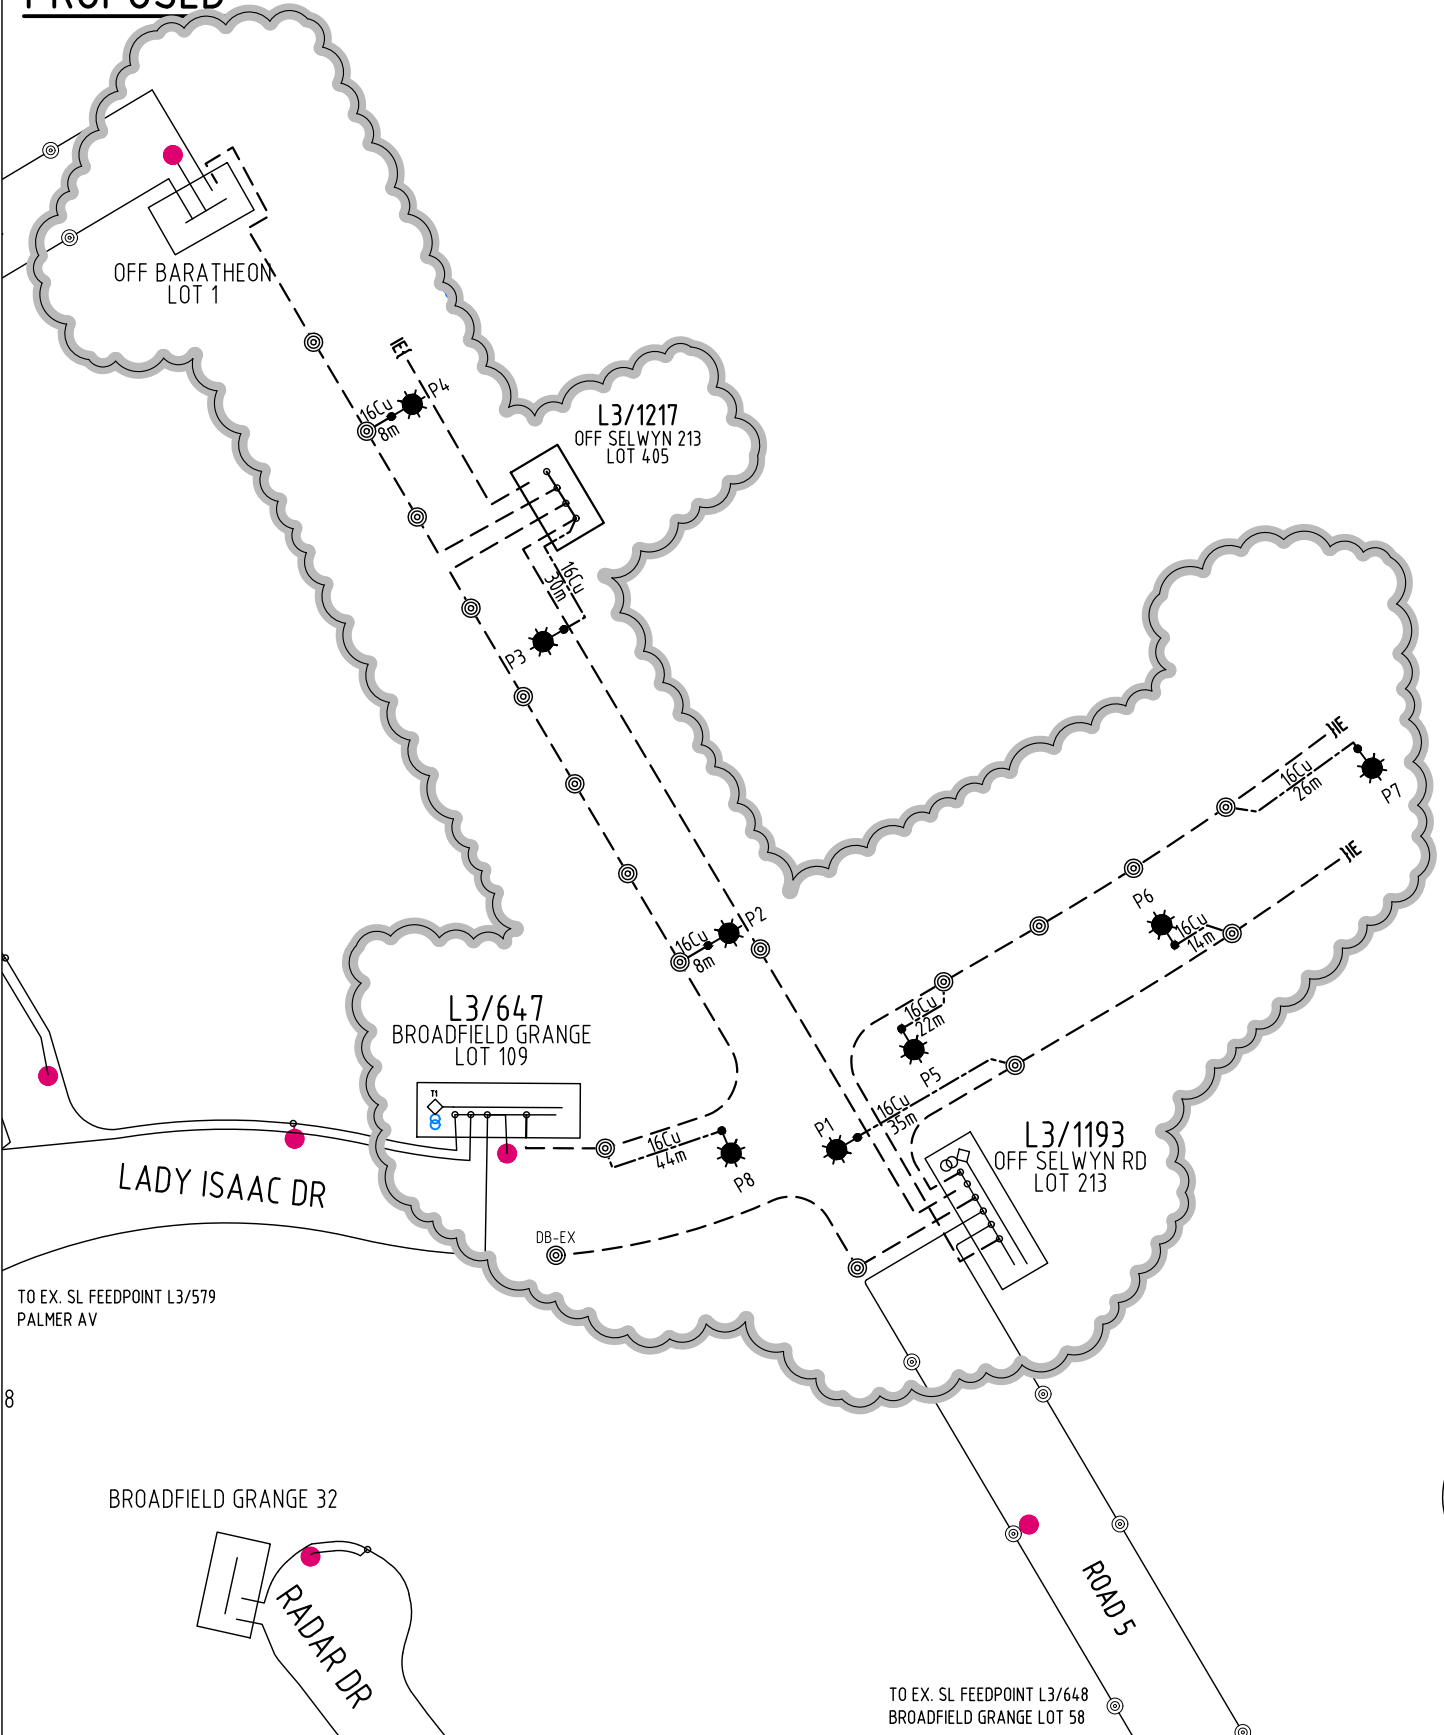


BROADFIELD GRANGE STAGE 13

SL SCHEMATICS
EXISTING & PROPOSED



SCALE(SIZE)	DRAWING NO.	SHEET
NTS (A3)	107293	SL-01

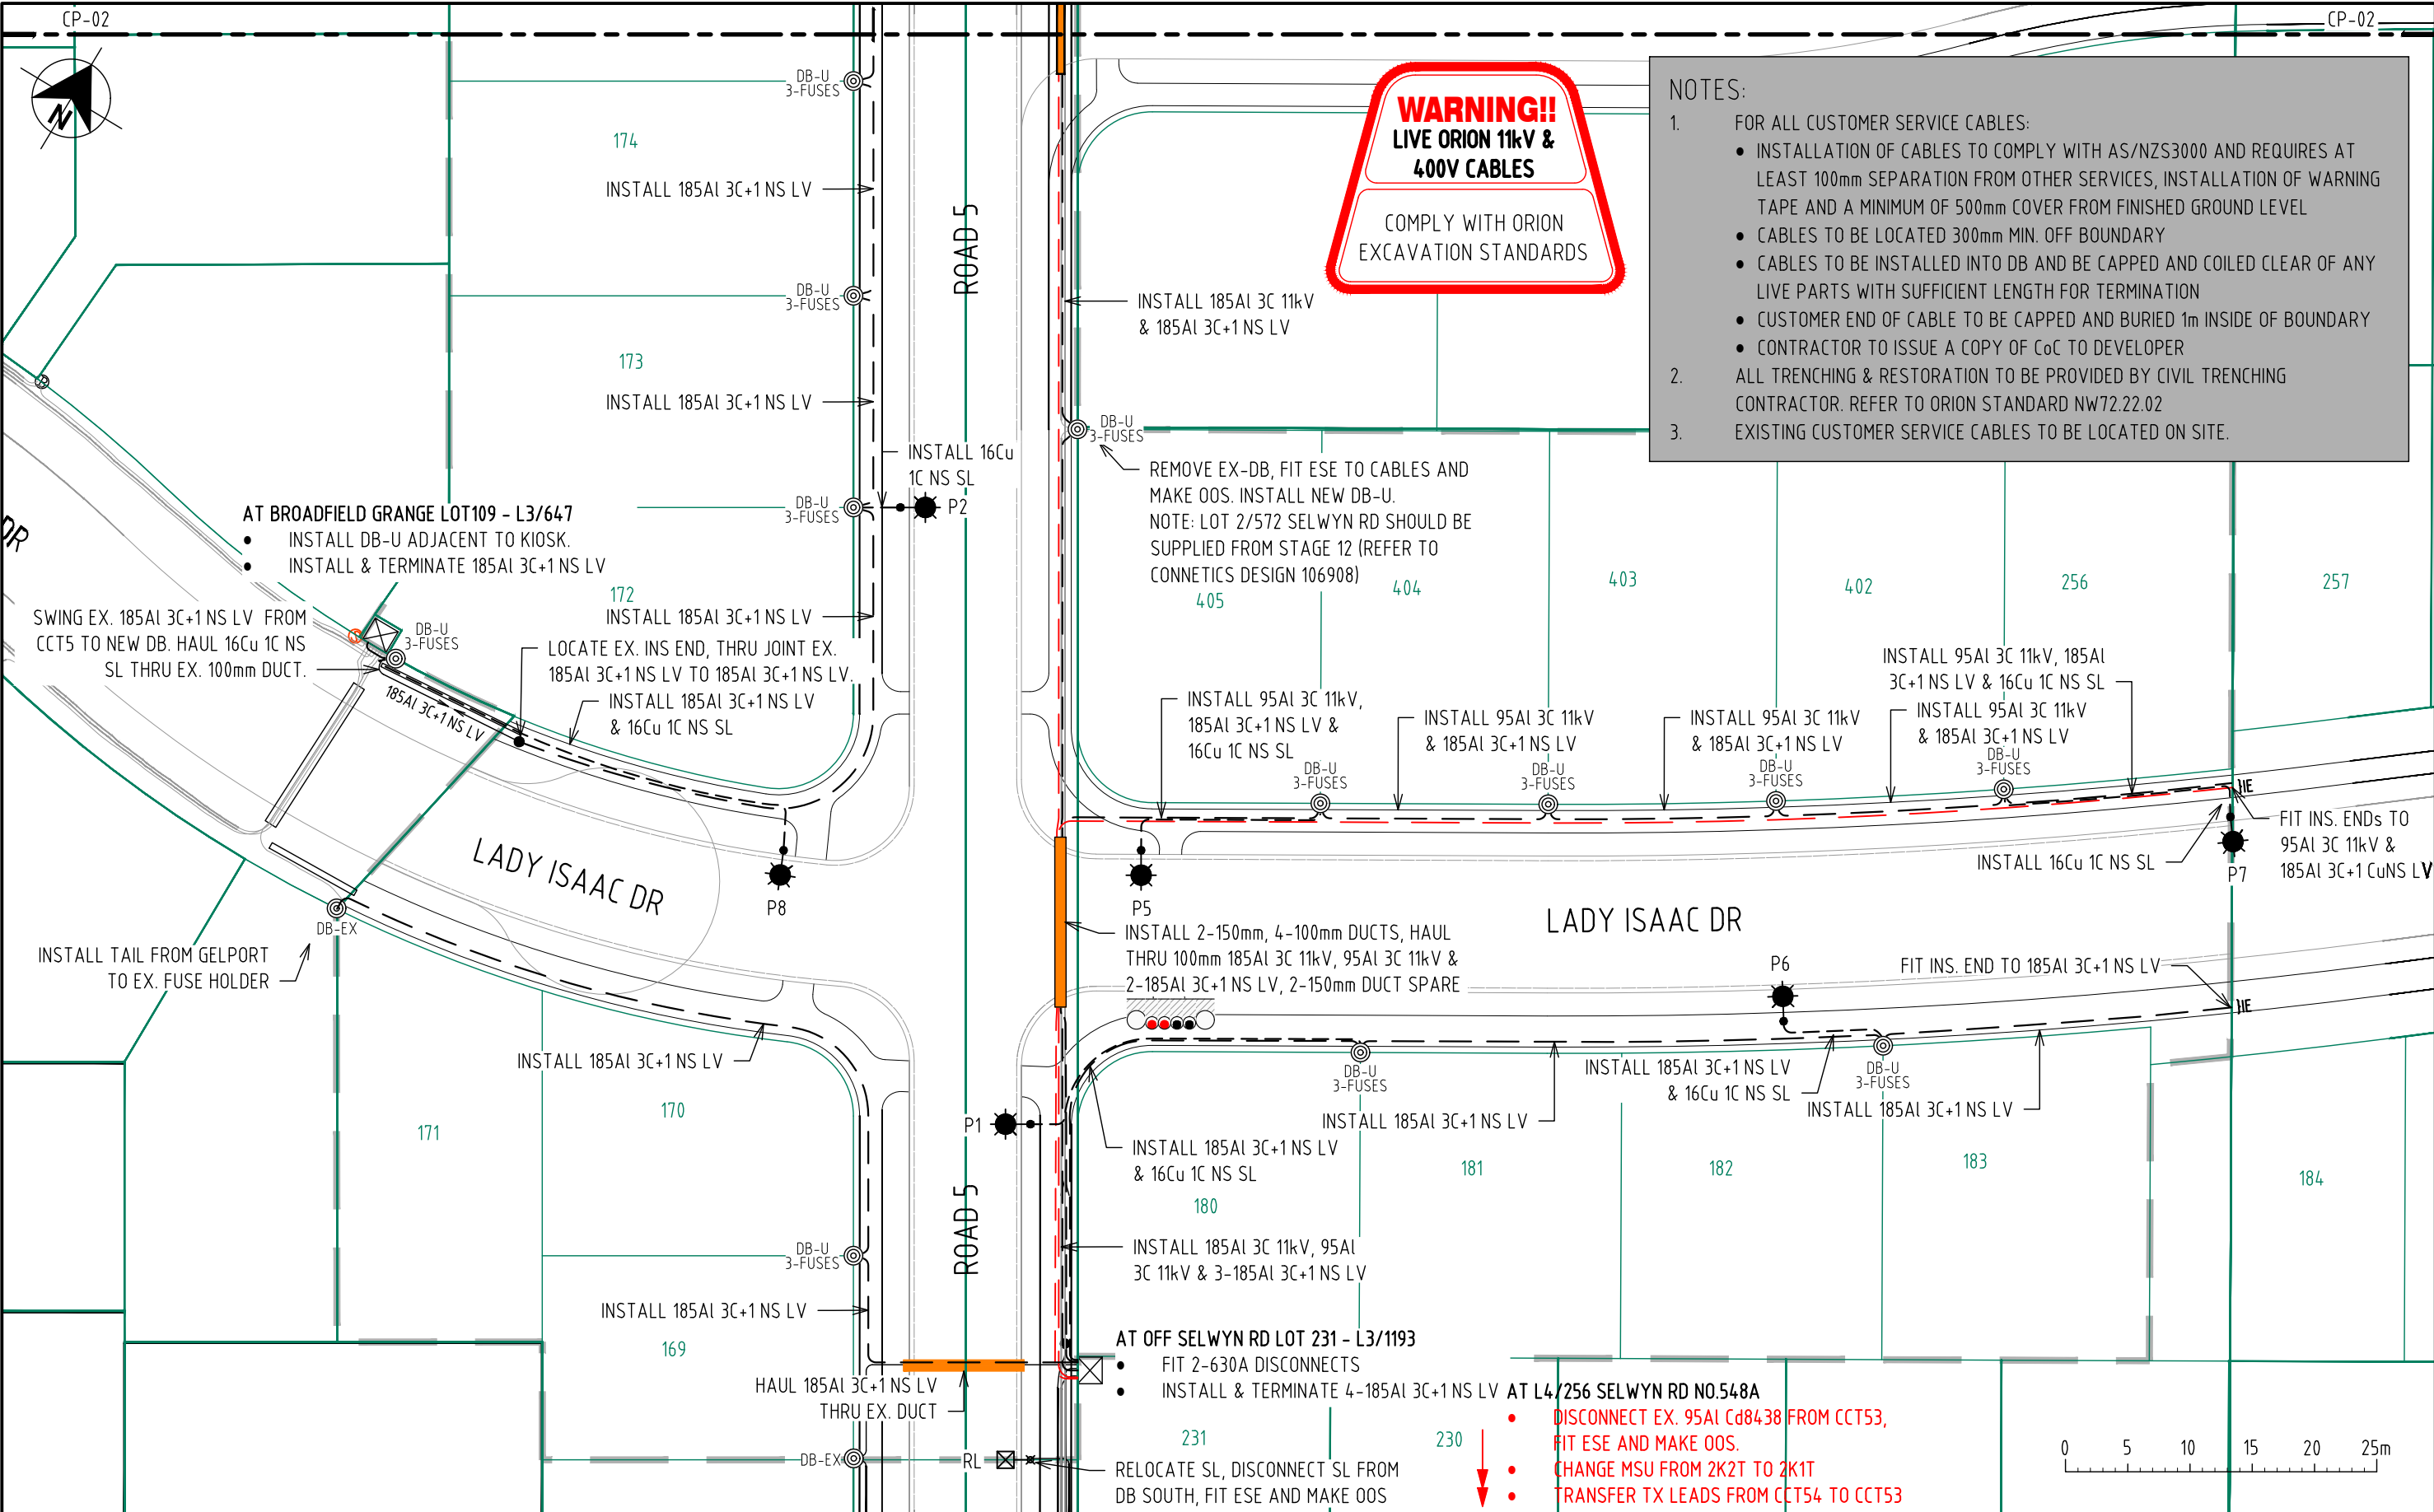

ISSUE	DESCRIPTION	DATE	DESIGN	DRAWN	CHECKD	TASK	NAME	SIGNATURE	DATED
A	ISSUED FOR CONSTRUCTION	14/10/25	R.P.	R.P.	M.O.	DESIGNED	R. PARKES		14/10/25
						DRAWN	R. PARKES		19/09/25
						CHECKED	M. OPHUIS		19/09/25
						APPROVED			
						ORN1021836	CONNETICS LIMITED. ALL RIGHTS RESERVED UNAUTHORISED USE PROHIBITED		A


BROADFIELD GRANGE STAGE 13

CABLE PLAN




ALL WAYS CONNECTING

SCALE(SIZE)	DRAWING NO.	SHEET
1:500 (A3)	107293	CP-01

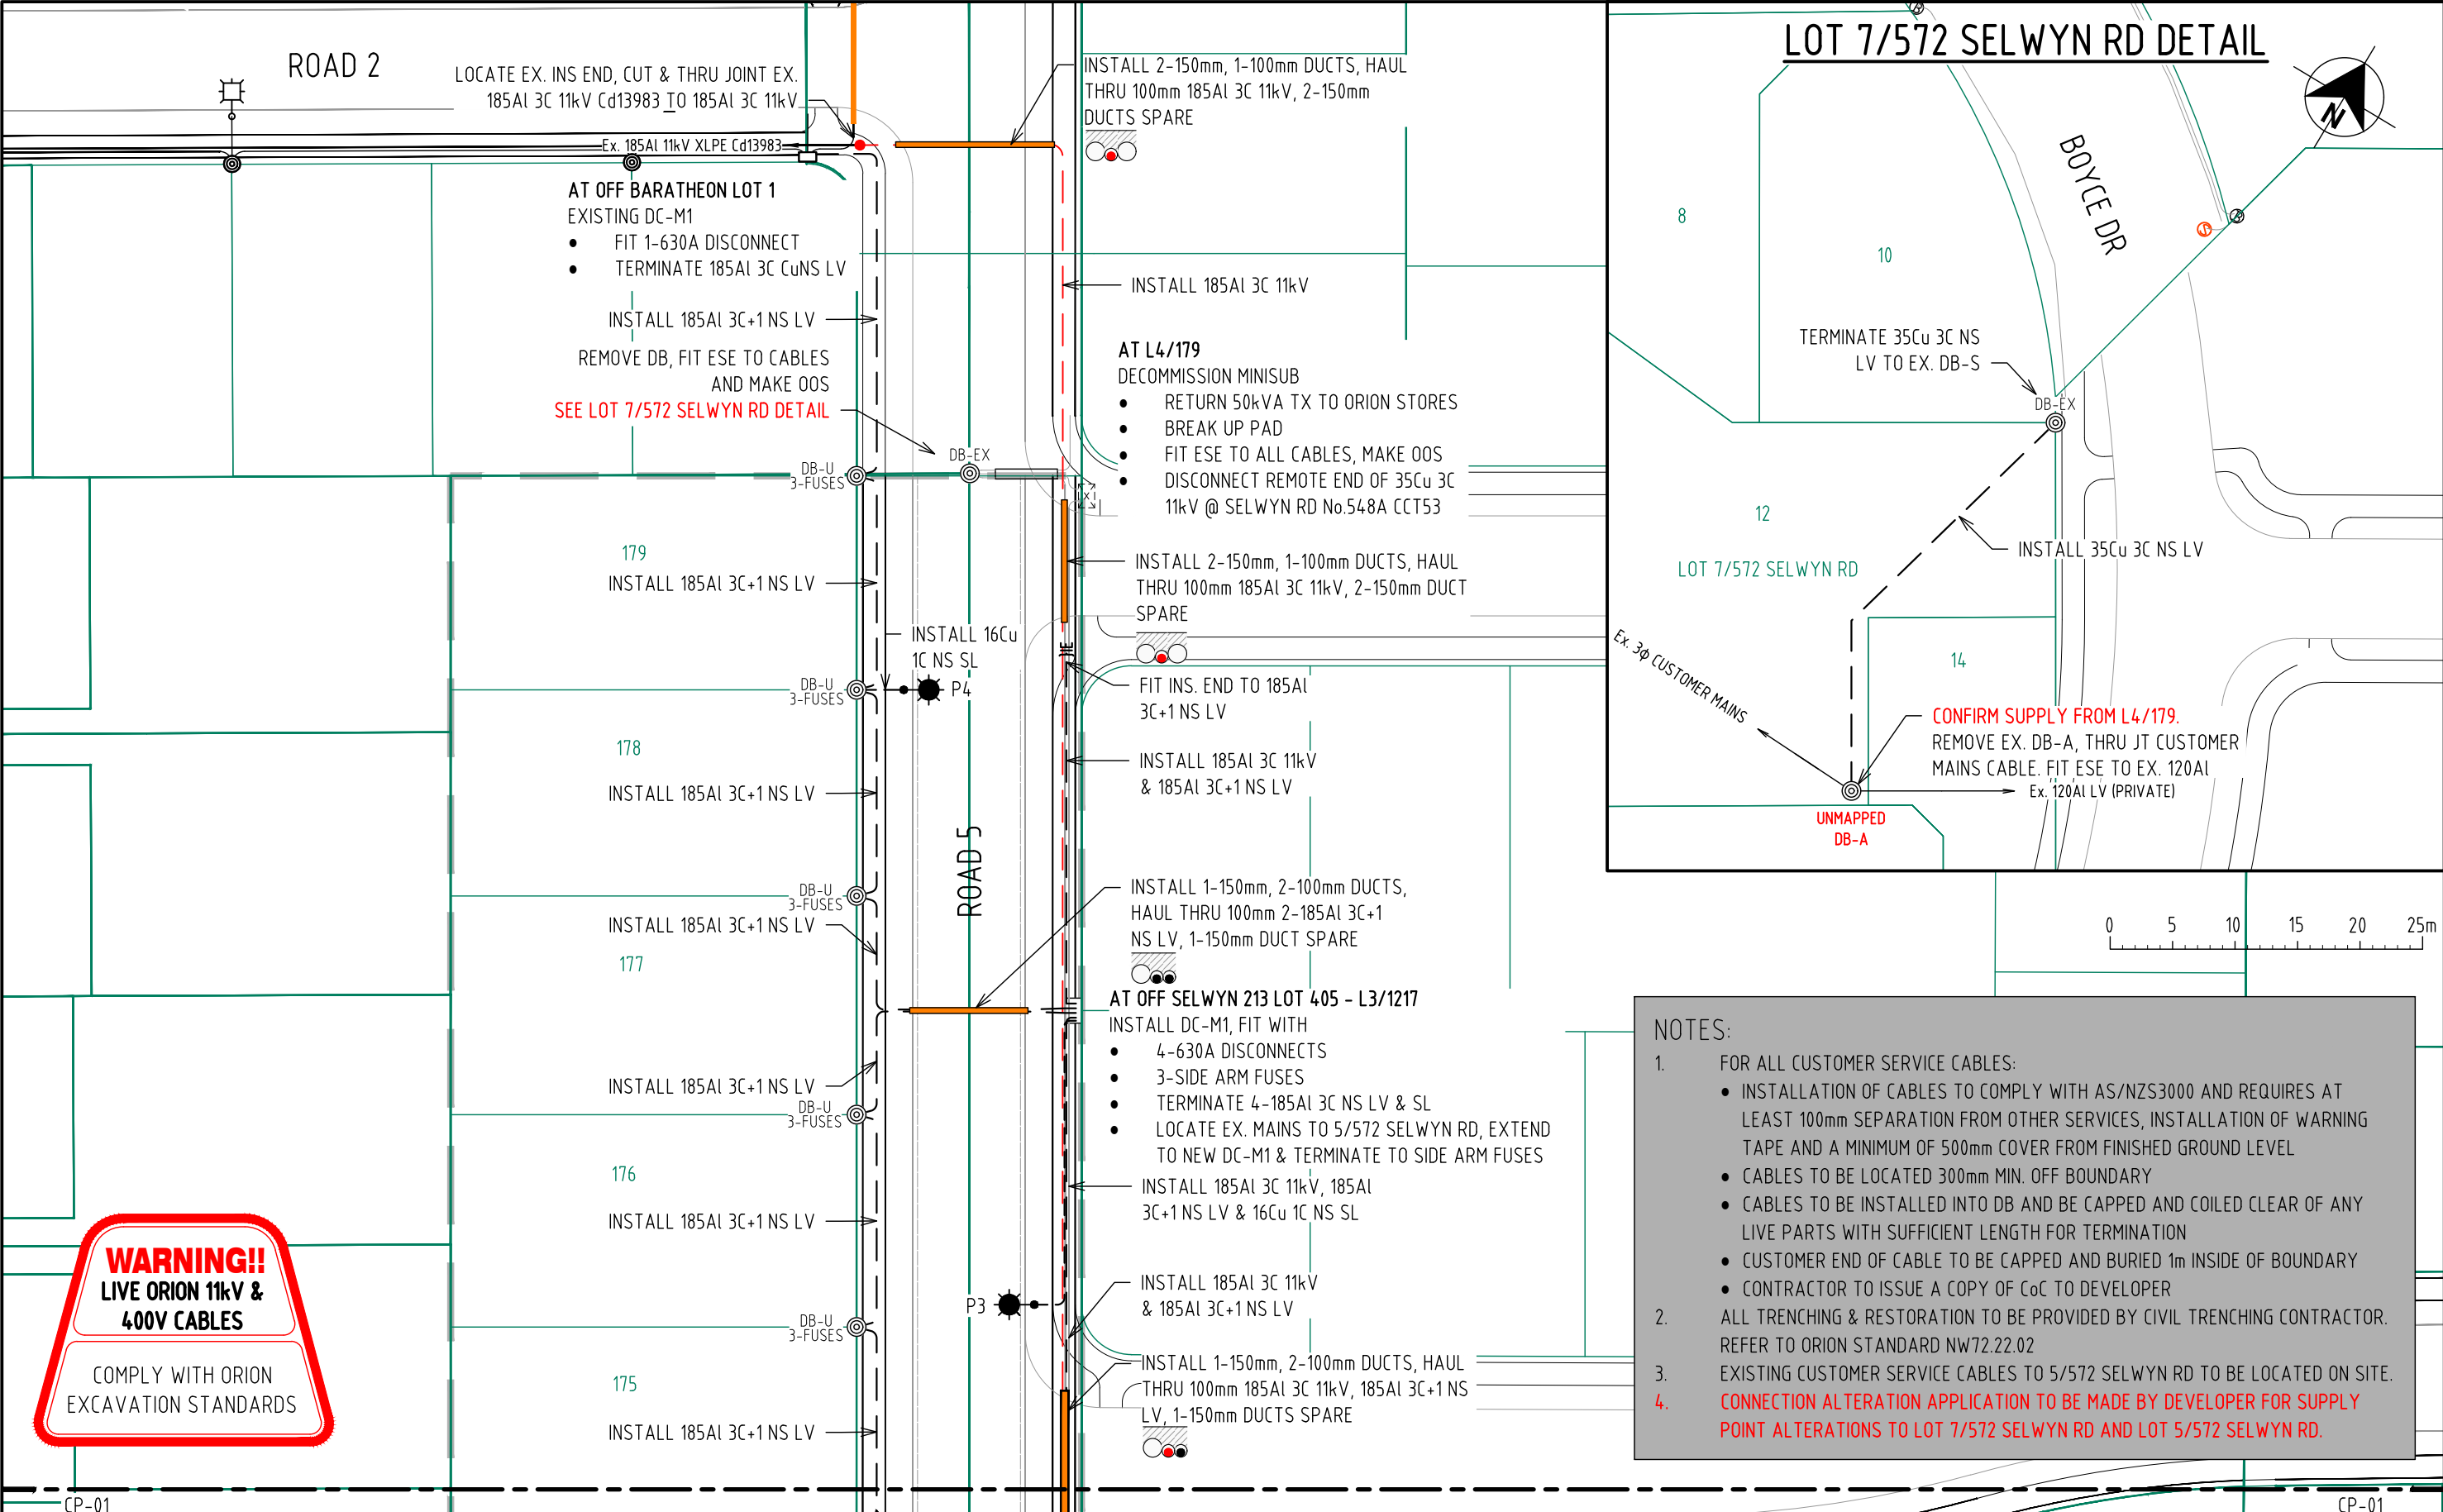

- NOTES:
- FOR ALL CUSTOMER SERVICE CABLES:
 - INSTALLATION OF CABLES TO COMPLY WITH AS/NZS3000 AND REQUIRES AT LEAST 100mm SEPARATION FROM OTHER SERVICES, INSTALLATION OF WARNING TAPE AND A MINIMUM OF 500mm COVER FROM FINISHED GROUND LEVEL
 - CABLES TO BE LOCATED 300mm MIN. OFF BOUNDARY
 - CABLES TO BE INSTALLED INTO DB AND BE CAPPED AND COILED CLEAR OF ANY LIVE PARTS WITH SUFFICIENT LENGTH FOR TERMINATION
 - CUSTOMER END OF CABLE TO BE CAPPED AND BURIED 1m INSIDE OF BOUNDARY
 - CONTRACTOR TO ISSUE A COPY OF CoC TO DEVELOPER
 - ALL TRENCHING & RESTORATION TO BE PROVIDED BY CIVIL TRENCHING CONTRACTOR. REFER TO ORION STANDARD NW72.22.02
 - EXISTING CUSTOMER SERVICE CABLES TO 5/572 SELWYN RD TO BE LOCATED ON SITE.
 - CONNECTION ALTERATION APPLICATION TO BE MADE BY DEVELOPER FOR SUPPLY POINT ALTERATIONS TO LOT 7/572 SELWYN RD AND LOT 5/572 SELWYN RD.

ISSUE	DESCRIPTION	DATE	DESIGN	DRAWN	CHECKD	TASK	NAME	SIGNATURE	DATED	BROADFIELD GRANGE STAGE 13			 ALL WAYS CONNECTING		
A	ISSUED FOR CONSTRUCTION	14/10/25	R.P.	R.P.	M.O.	DESIGNED	R. PARKES		14/10/25						
						DRAWN	R. PARKES		19/09/25						
						CHECKED	M. OPHUIS		19/09/25						
						APPROVED				CABLE PLAN			SCALE(SIZE)	DRAWING NO.	SHEET
						ORN1021836	 CONNETICS LIMITED. ALL RIGHTS RESERVED UNAUTHORISED USE PROHIBITED		A				1:500 (A3)	107293	CP-02

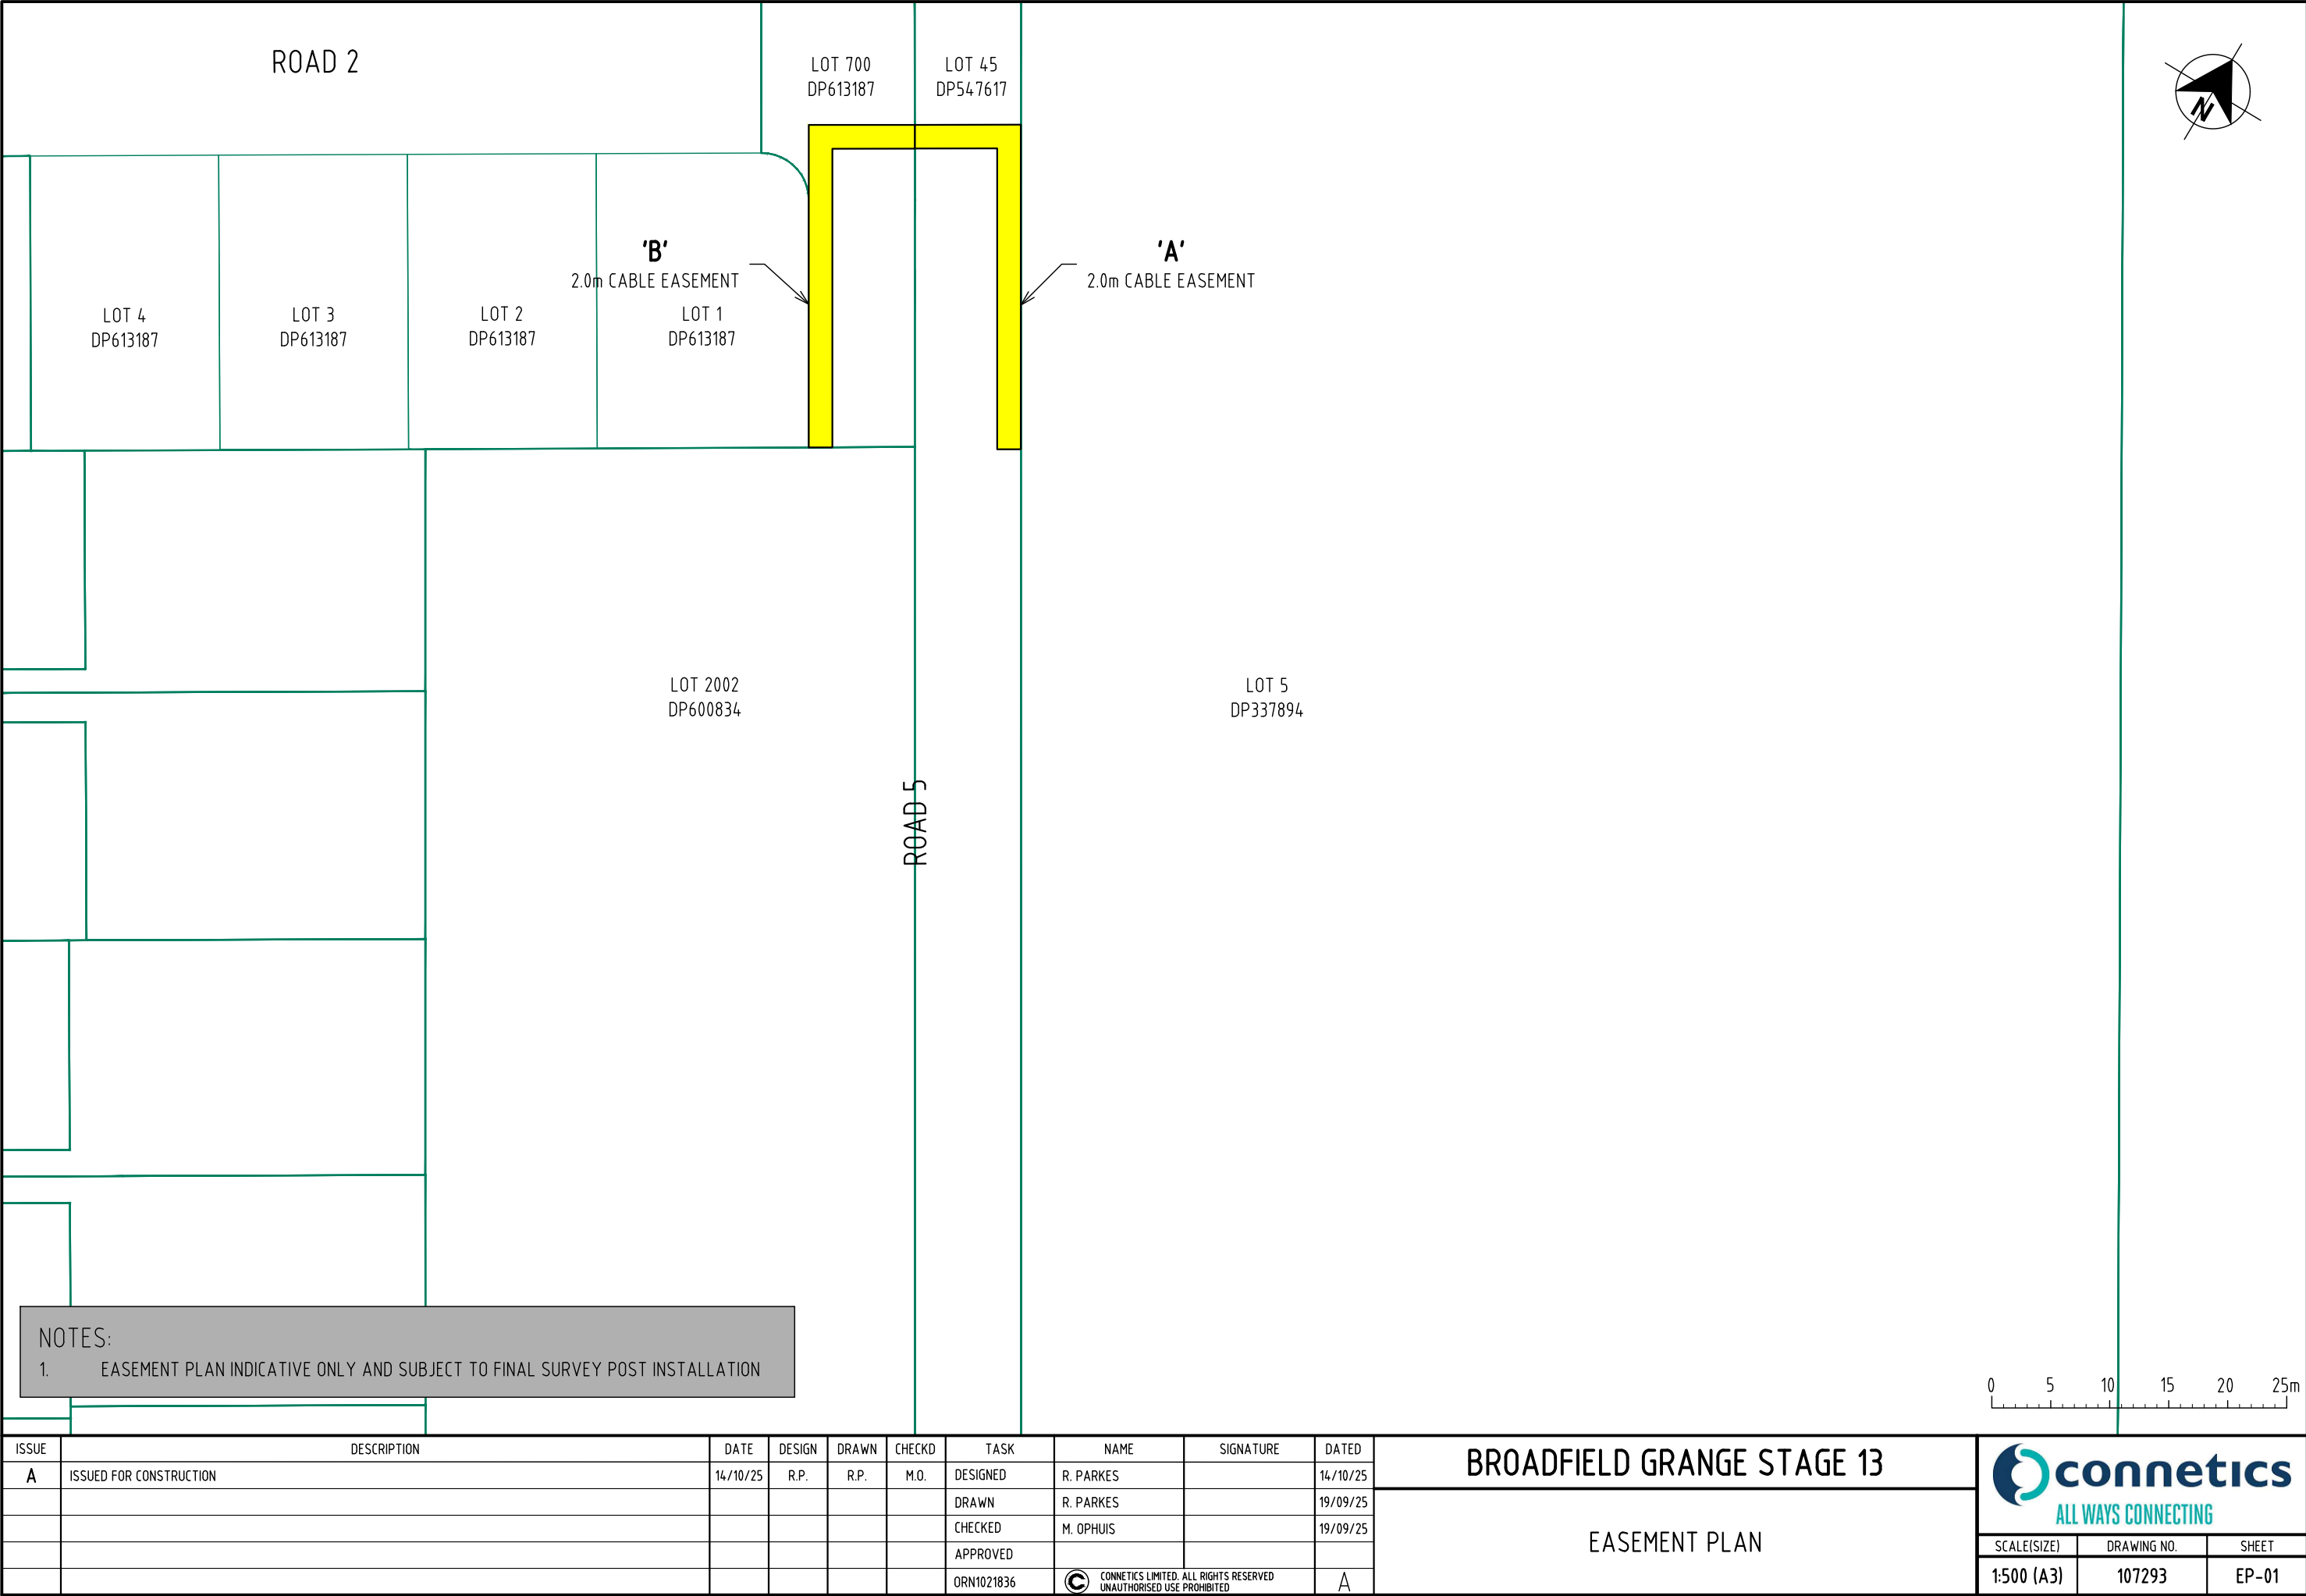



ISSUE	DESCRIPTION	DATE	DESIGN	DRAWN	CHECKD	TASK	NAME	SIGNATURE	DATED
A	ISSUED FOR CONSTRUCTION	14/10/25	R.P.	R.P.	M.O.	DESIGNED	R. PARKES		14/10/25
						DRAWN	R. PARKES		19/09/25
						CHECKED	M. OPHUIS		19/09/25
						APPROVED			
						ORN1021836	CONNETICS LIMITED. ALL RIGHTS RESERVED UNAUTHORISED USE PROHIBITED		A

BROADFIELD GRANGE STAGE 13

EASEMENT PLAN

ALL WAYS CONNECTING

SCALE(SIZE)	DRAWING NO.	SHEET
1:500 (A3)	107293	EP-01

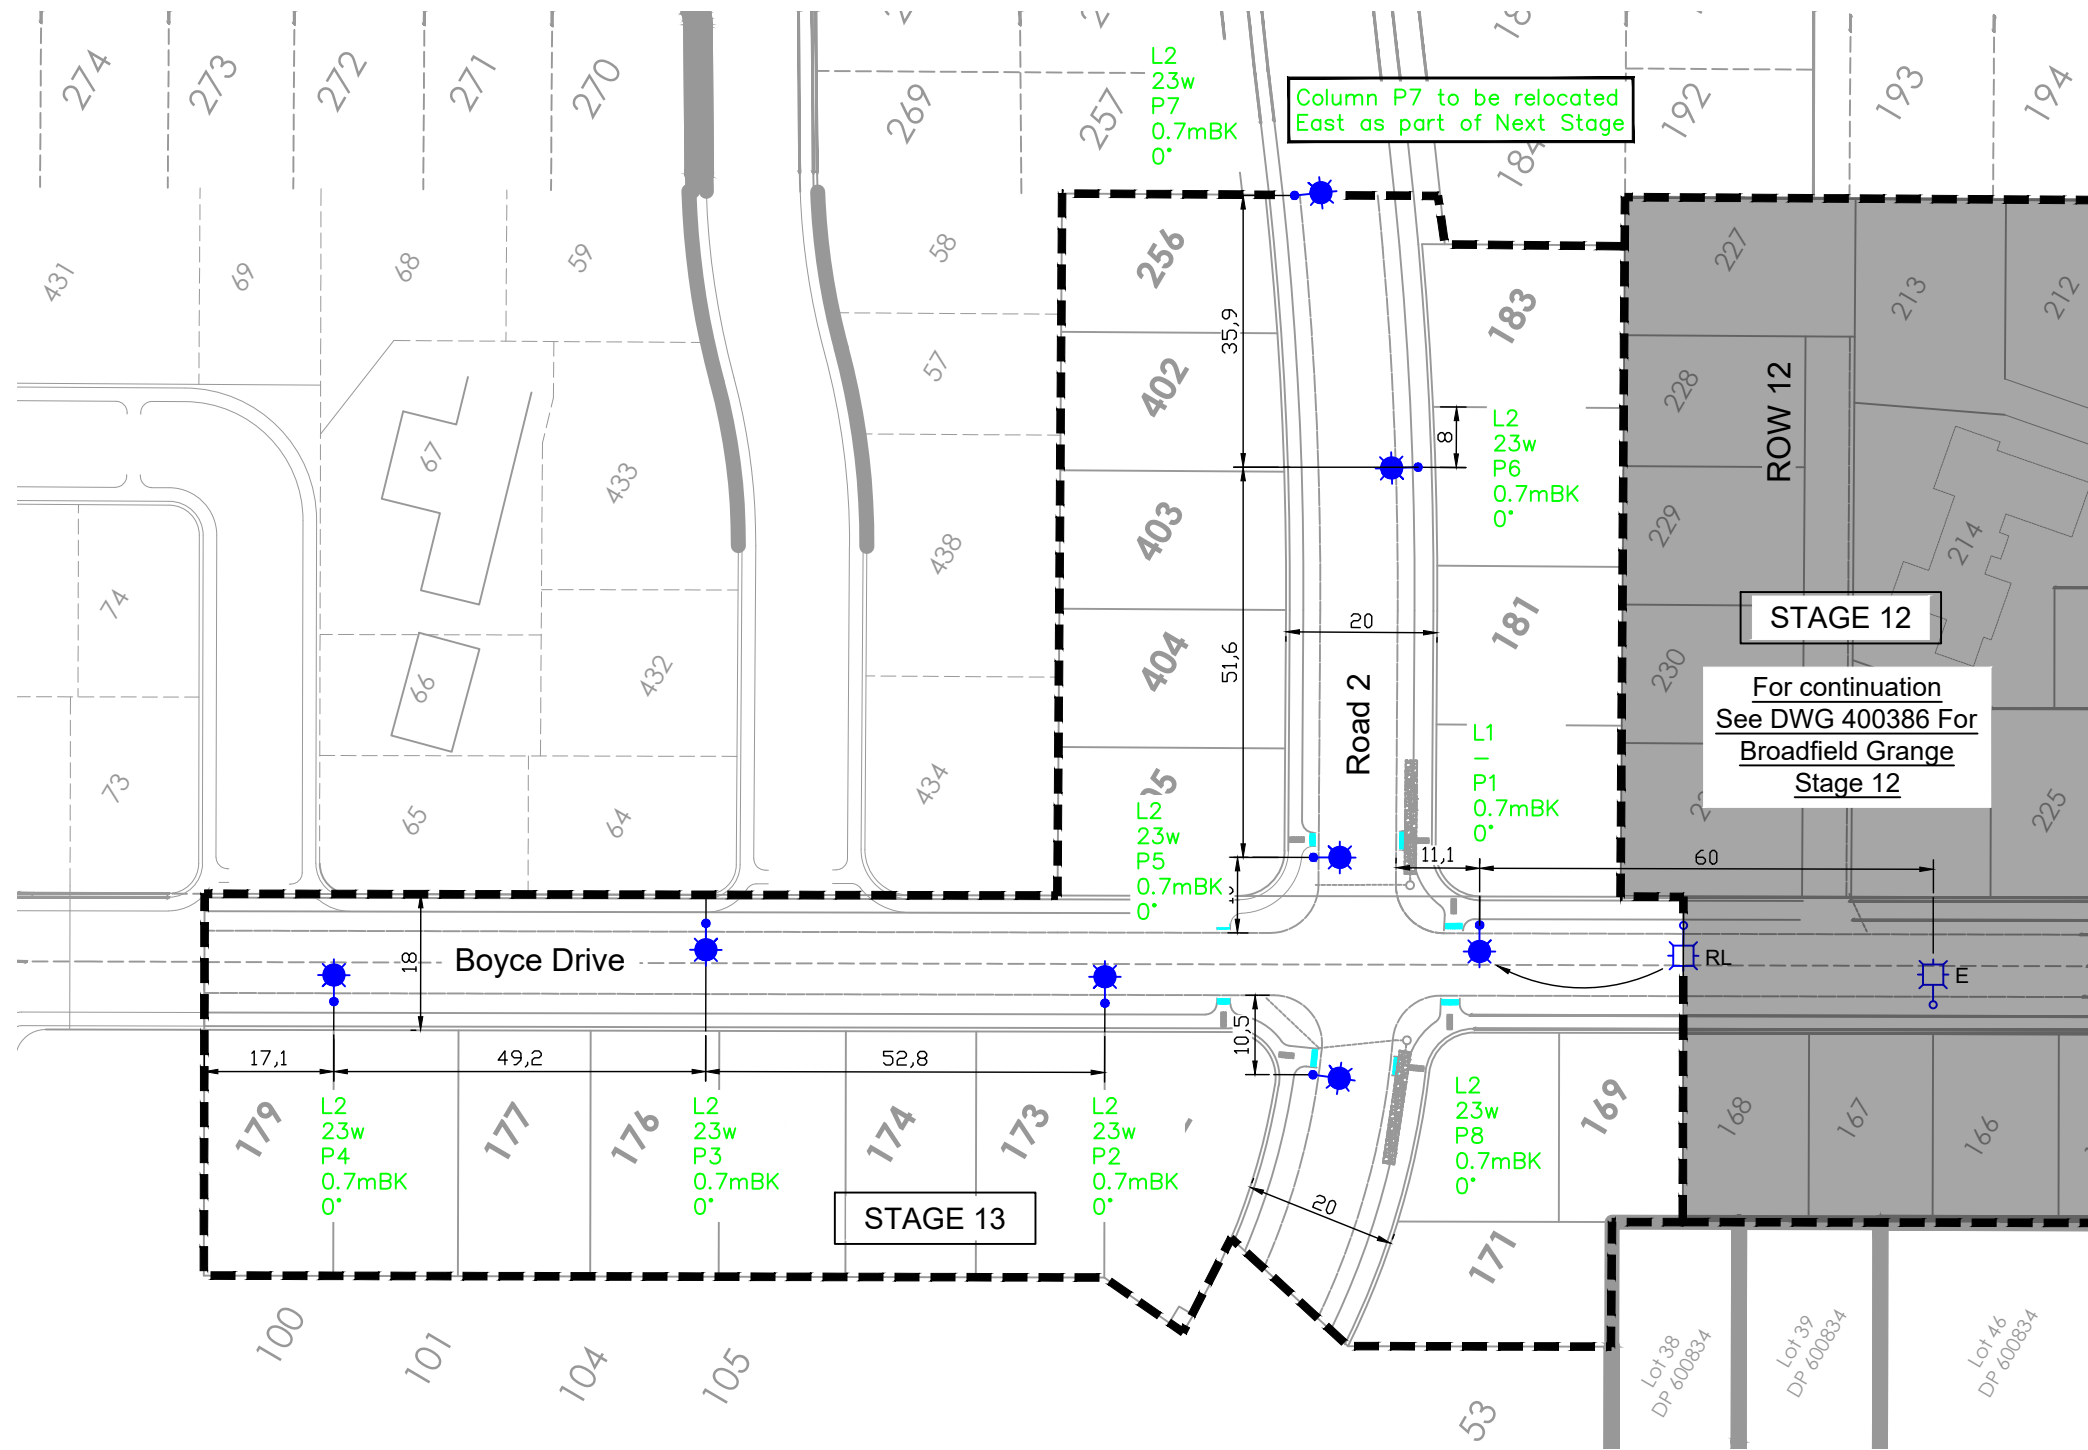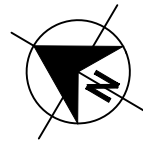

NOTES:

1. Refer to Sheet 1 for Luminaire Schedule and Legend.

ISSUED FOR INFORMATION
Monday, 29 September 2025 3:54:57 pm
NOT FOR CONSTRUCTION



WINDSOR URBAN LTD.
ALL RIGHTS RESERVED.
UNAUTHORISED USE PROHIBITED

Rev	Description	Date	Des	Dn	Chk	Apd	Or Acp	Contractor	Designed	R. St-Denis / Conn	Aug 25	Scale
A	Issued to Client for Comments	14/08/25	RSD	RSD	-	-	-	-	Drawn	R. St-Denis / Conn	Aug 25	1:1000
									Checked	J. Lim / Conn	-	
									Approved	B. Hayman for SDC	-	
												Revision
												A
									Connetics	-	-	

STREETLIGHTING LAYOUT

Broadfield Grange Sub-Division
Phase 2 - Stage 13
East Rolleston



611 Holmes Junction Rd, Hornby, Christchurch, NZ
Phone (03) 349-7653 Fax (03) 349-6529 Freephone (0800) 945-945
Email: www.windsorurban.co.nz

Size	Drawing Number	Sheet
A3	400403	2/2

1 : 1500

1 : 1000